






Drainage Layout - Level 0 (Production)  
scale 1:100

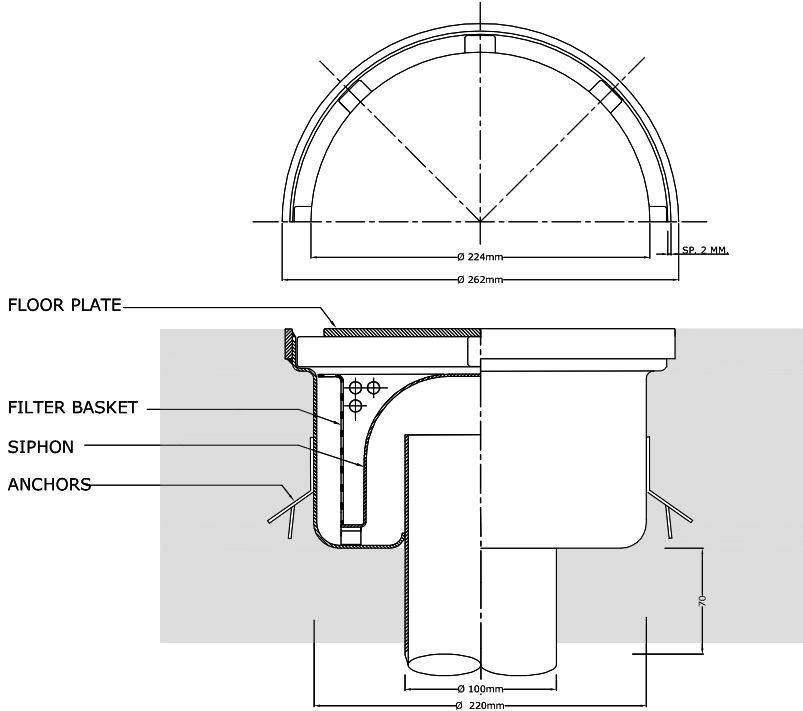


Detail of Drain Type FD1  
scale 1:5

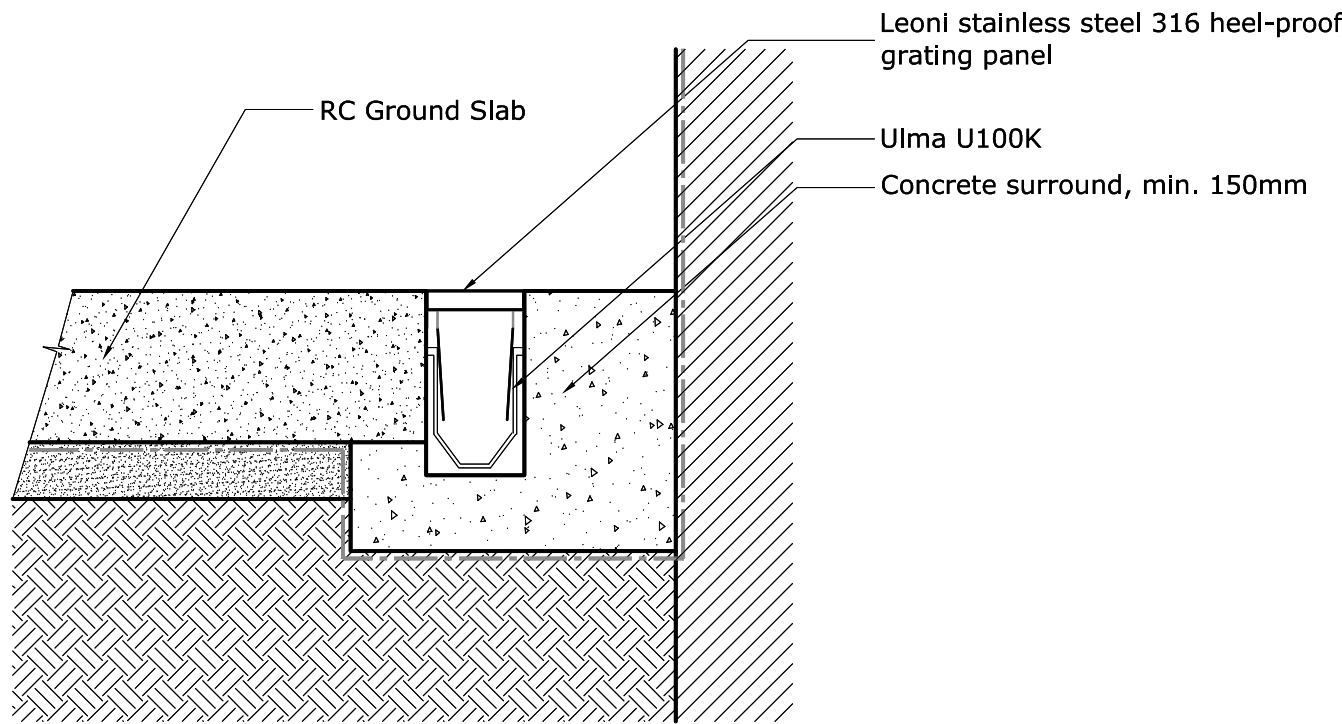

Detail of Channel Drain  
scale 1:10

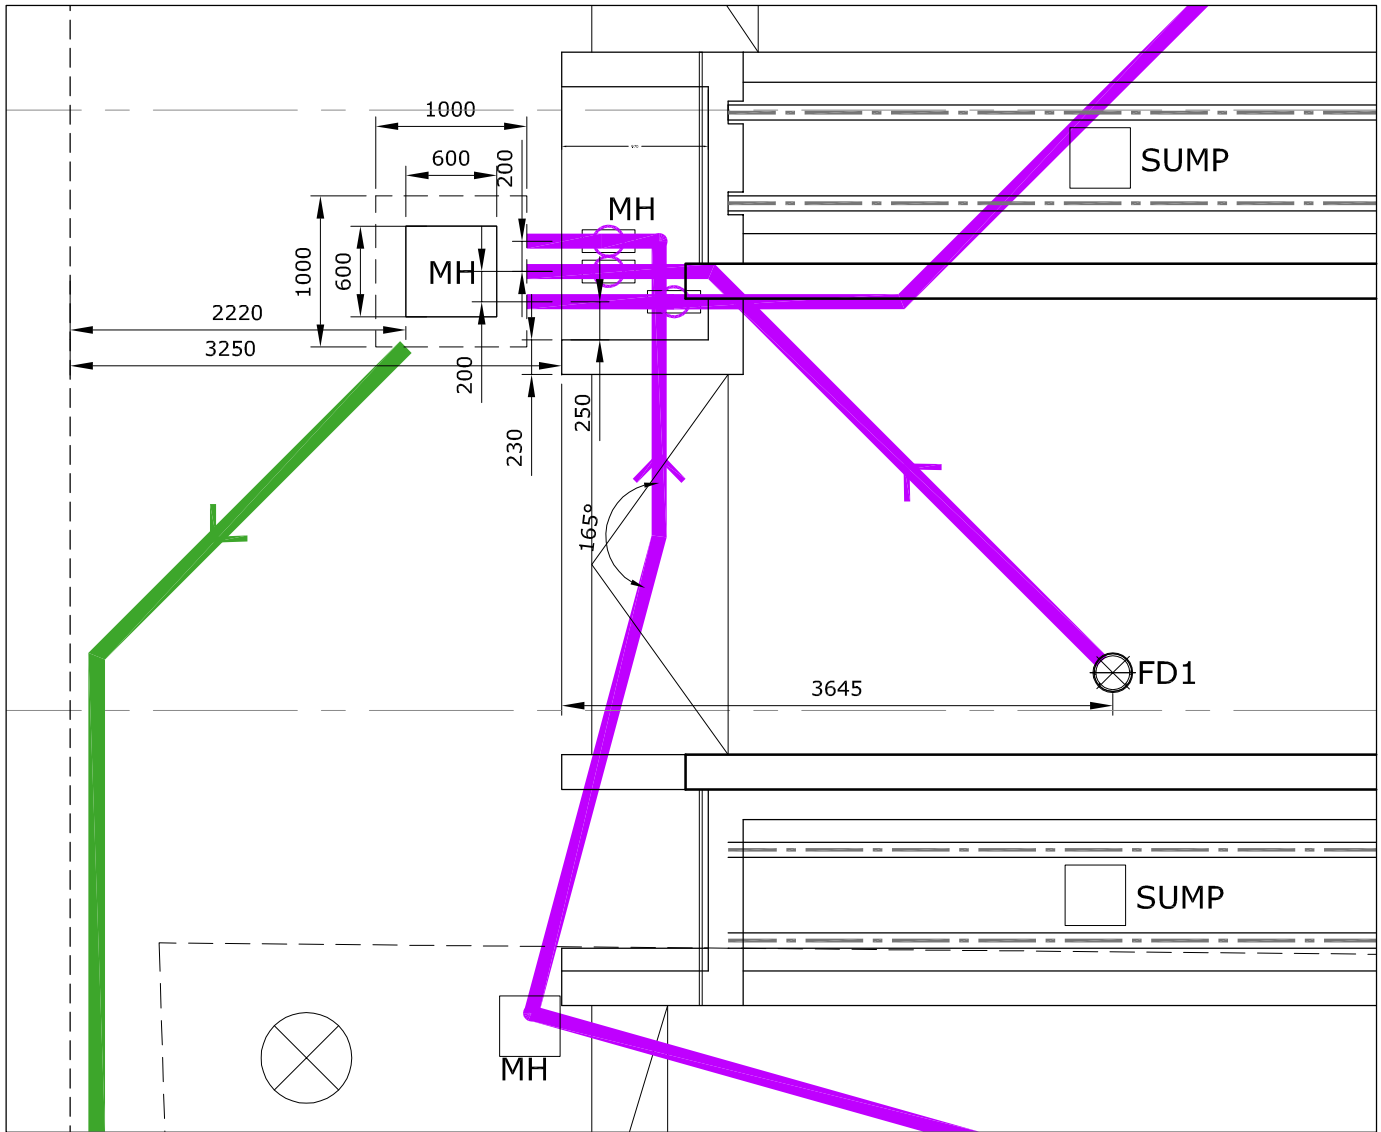

Detail A  
scale 1:50

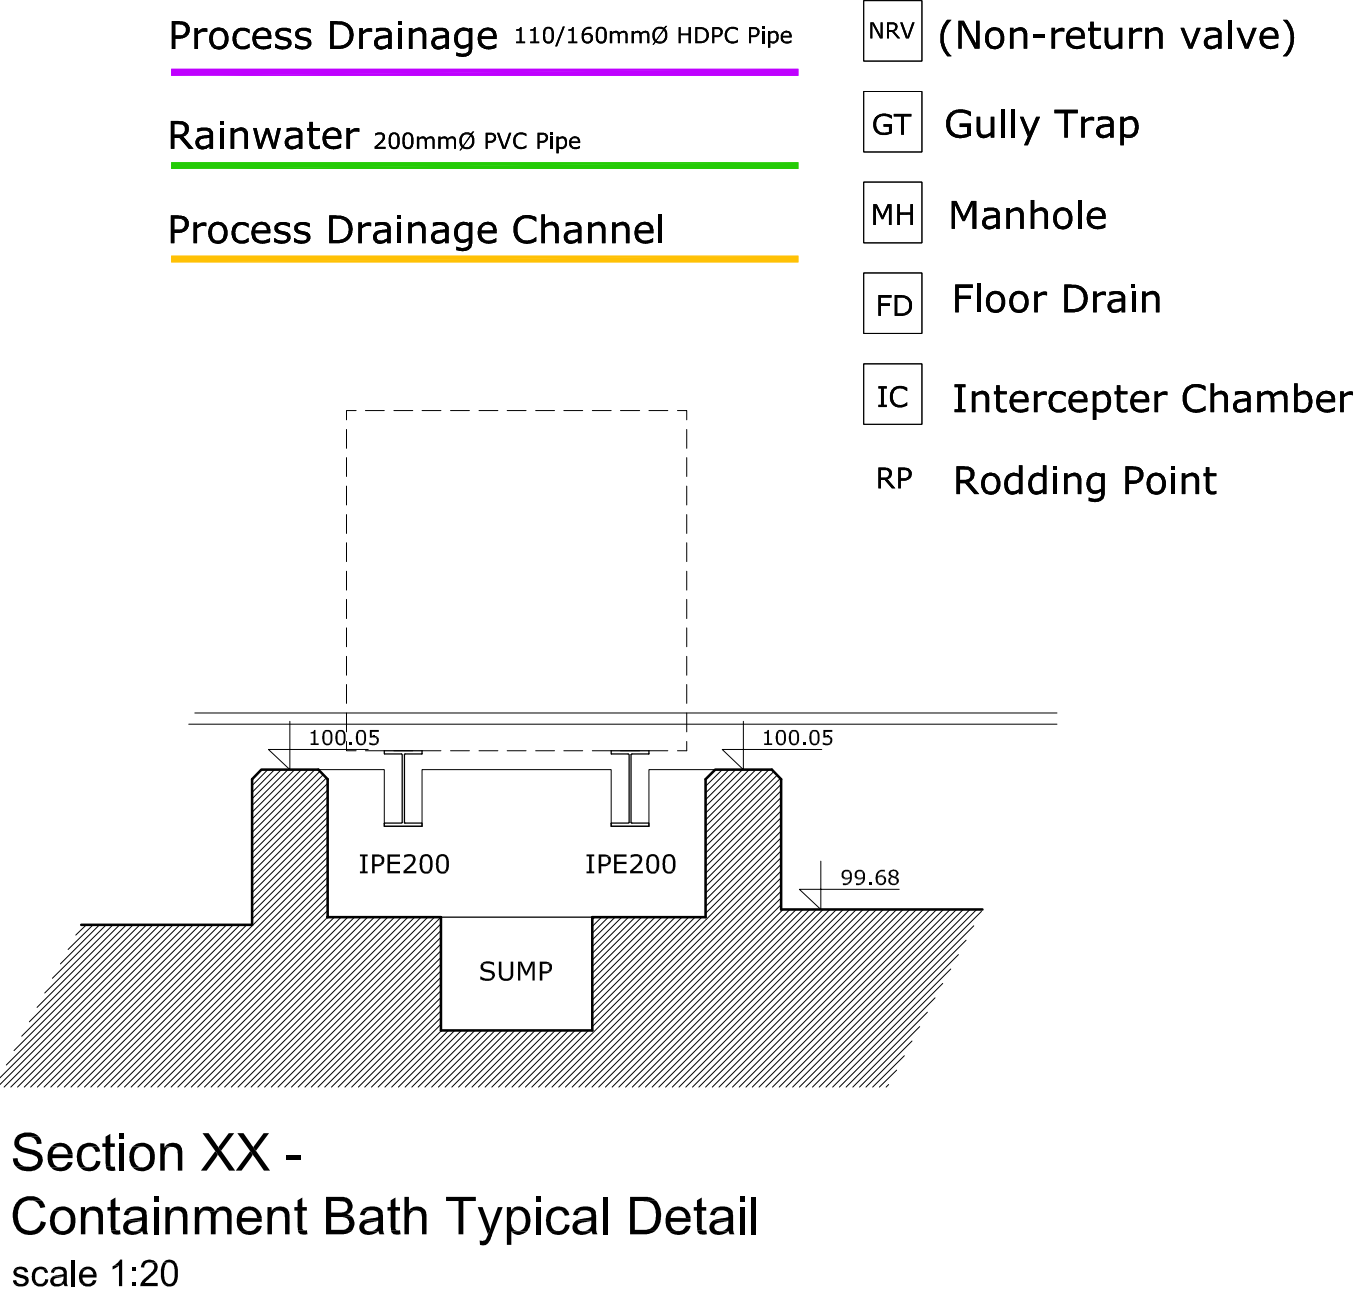

E	Amended drains for flammable warehouse extension	15/05/15
D	Amended drain layout in flammable warehouse area	01/03/12
C	Amended drain layout in loading/unloading area	12/12/11
B	Included of invert levels & modified gradients	18/10/11
A	Inclusion of Drain in Rm34	15/09/11
Rev.	Description	Date

Wallace Farrugia & Associates  
Architects, Civil Engineers & Structural Consultants.  
No 44, Appt 3, St Francis Street, Sliema SM05. Tel:21316758 fax: 21316760

Commission:  
Proposed Factory  
at Hal-Far

Client:  
STERLING SNIFF

Drawing Title:  
Drainage Layout  
Production - Level 0

Scale:  
1:100

Drawing No:  
38-06-212E

Job Ref:  
38/06

A

B

C

D

E

Drawn:  
td

Traced:  
--

Approved:  
--

Checked:  
w.f.

Date:  
07/09/11