


Drainage Layout - Level 0 (Administration)  
scale 1:100

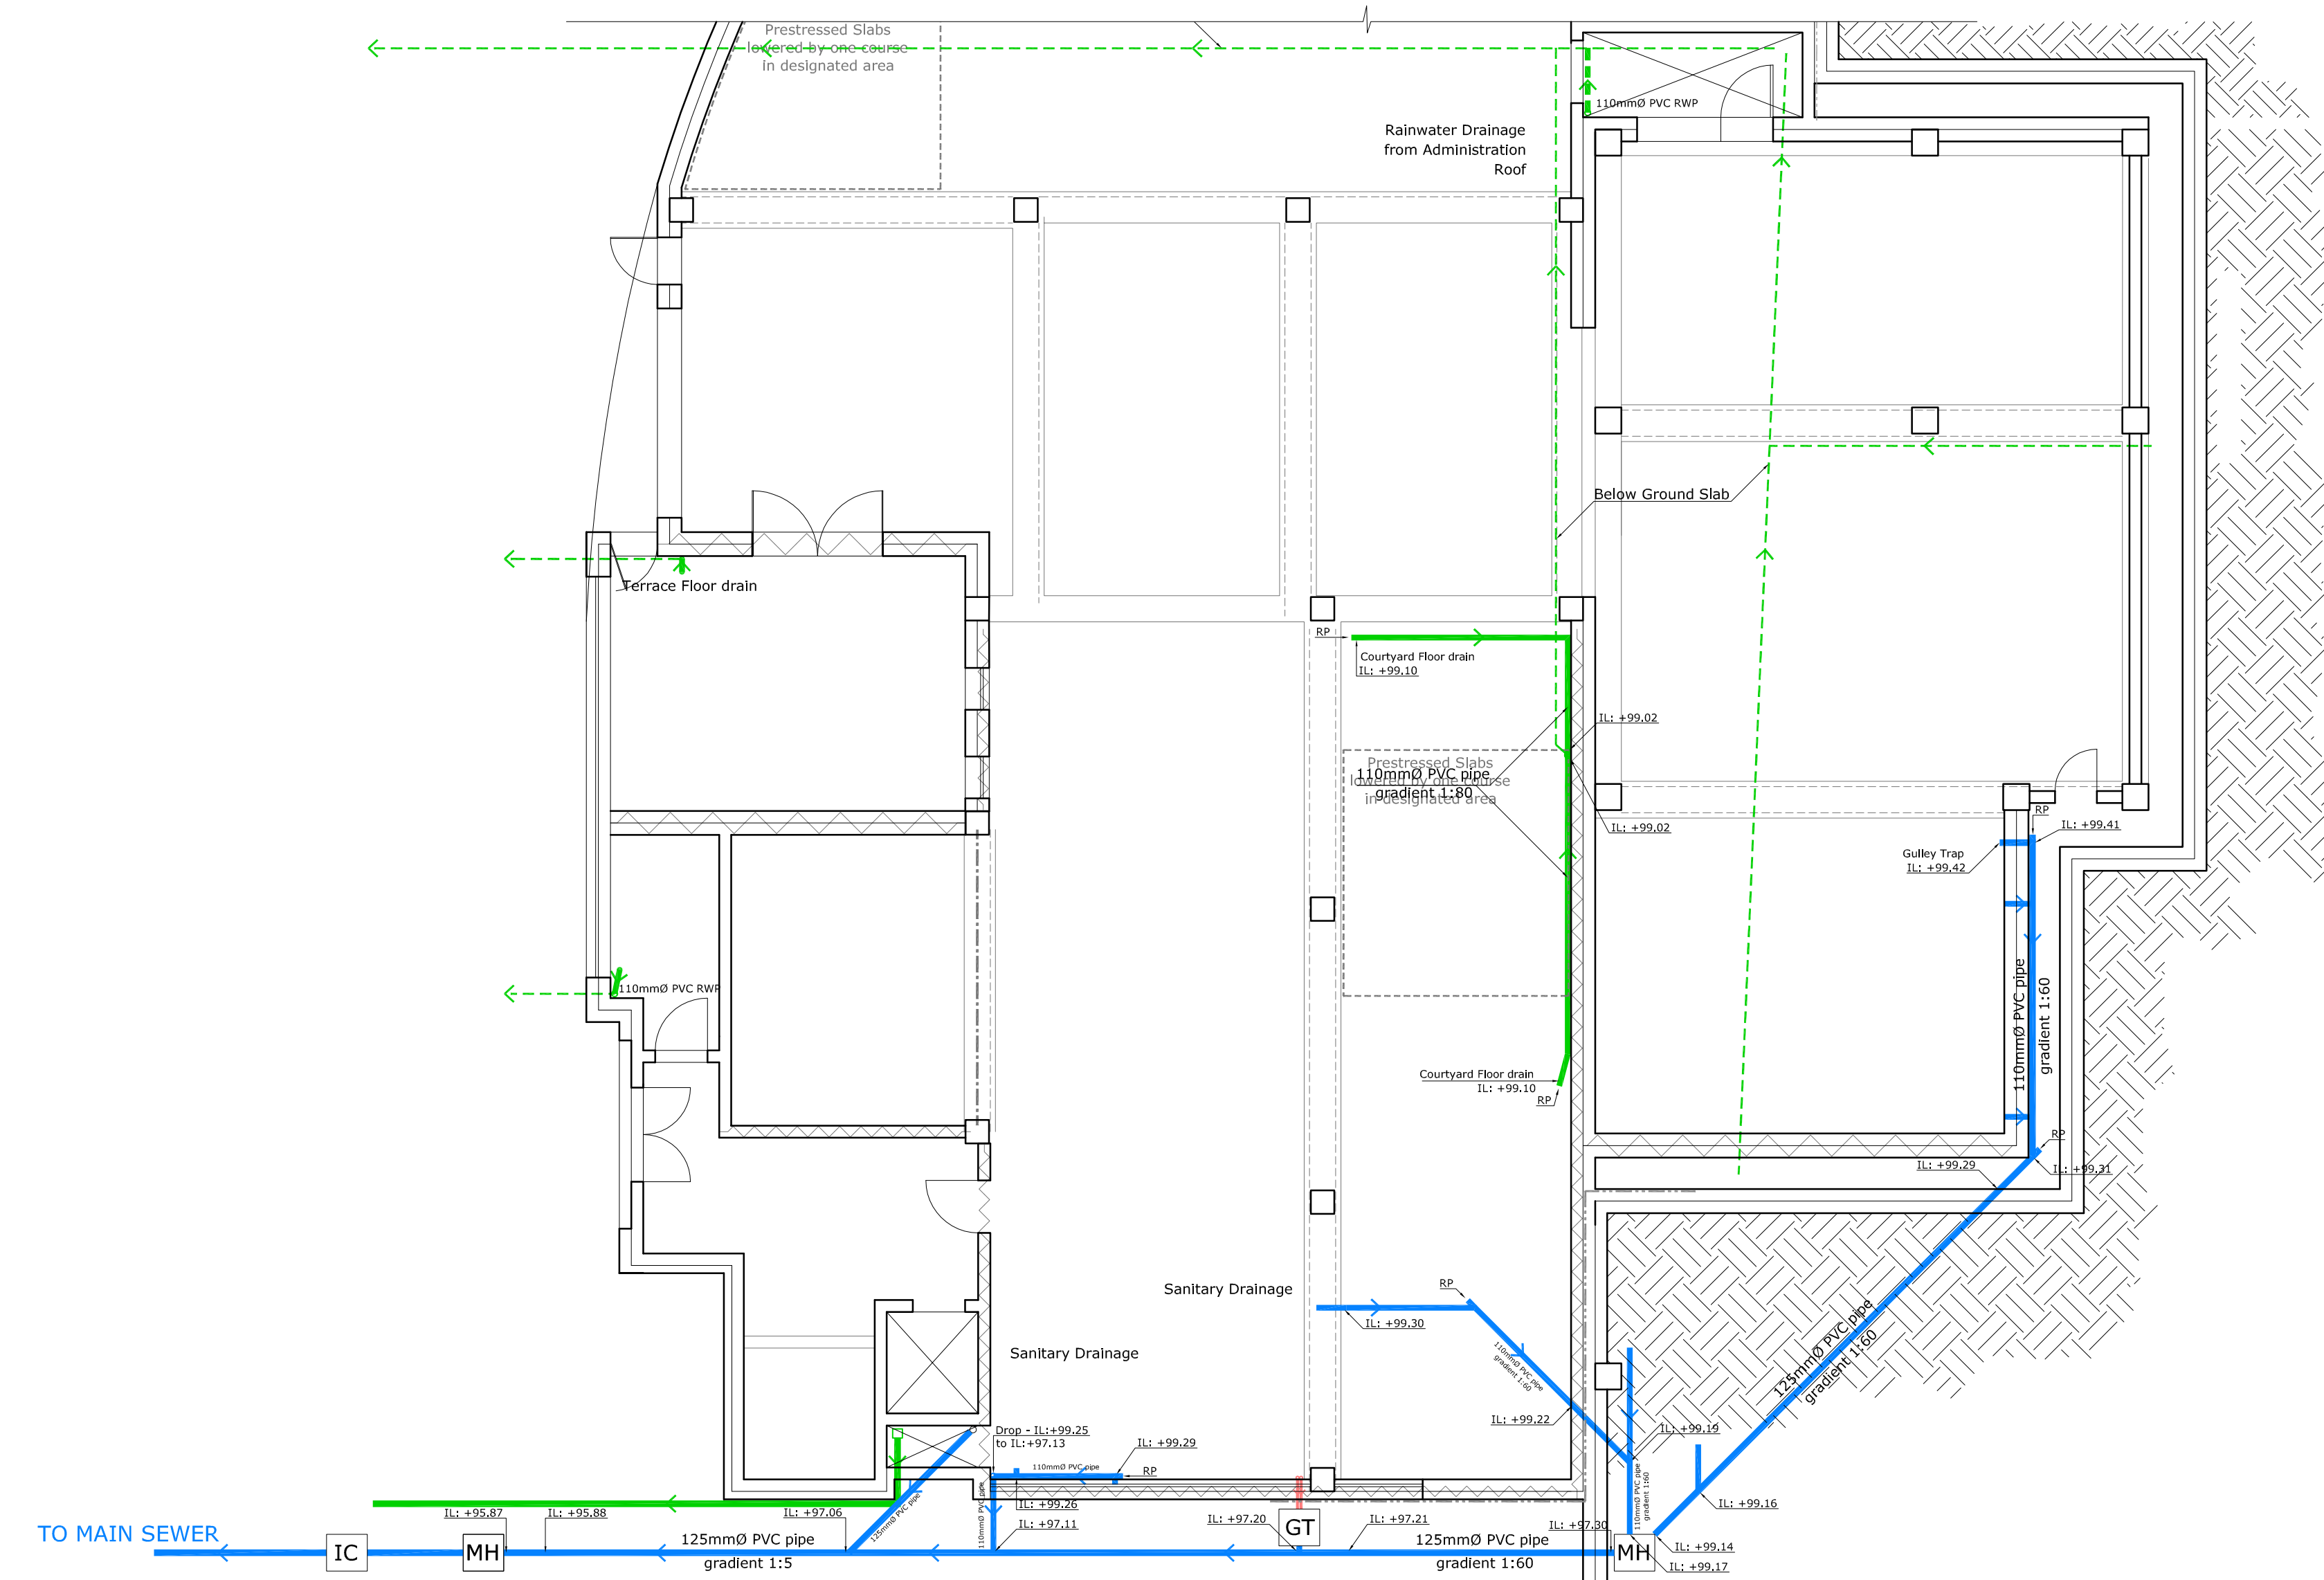

Drainage Layout - Basement Level  
scale 1:100

Sanitary Drainage 100/125mmØ PVC Pipe

Sanitary Drainage above

Water Discharge 60mmØ PVC Pipe

Rainwater Drainage

- NRV (Non-return valve)
- GT Gully Trap
- MH Manhole
- FD Floor Drain
- IC Interceptor Chamber
- RP Rodding Point

-	-	-
-	-	-
-	-	-
A	Included of invert levels & modified gradients	18/10/11
Rev.	Description	Date

  
**Wallace Farrugia & Associates**  
Architects, Civil Engineers & Structural Consultants.  
No 44, Apt 3, St.Francis Street, Slemra SLM05 tel:21316758 fax: 21316760

Commission:  
**Proposed Factory  
at Hal-Far**

Client:  
**STERLING SNIFF**

Drawing Title:									
Drainage Layout Administration Basement & Level 0									
Scale:					Drawing No:				
1:200					38-06-211A				
Job Ref:									
38/06									
					A - - - - -				
Drawn:		Traced:		Approved:		Checked:		Date:	
td		--		--		w.f.		07/09/1	