



APPENDIX II: MN FIRE SAFETY DRAWINGS

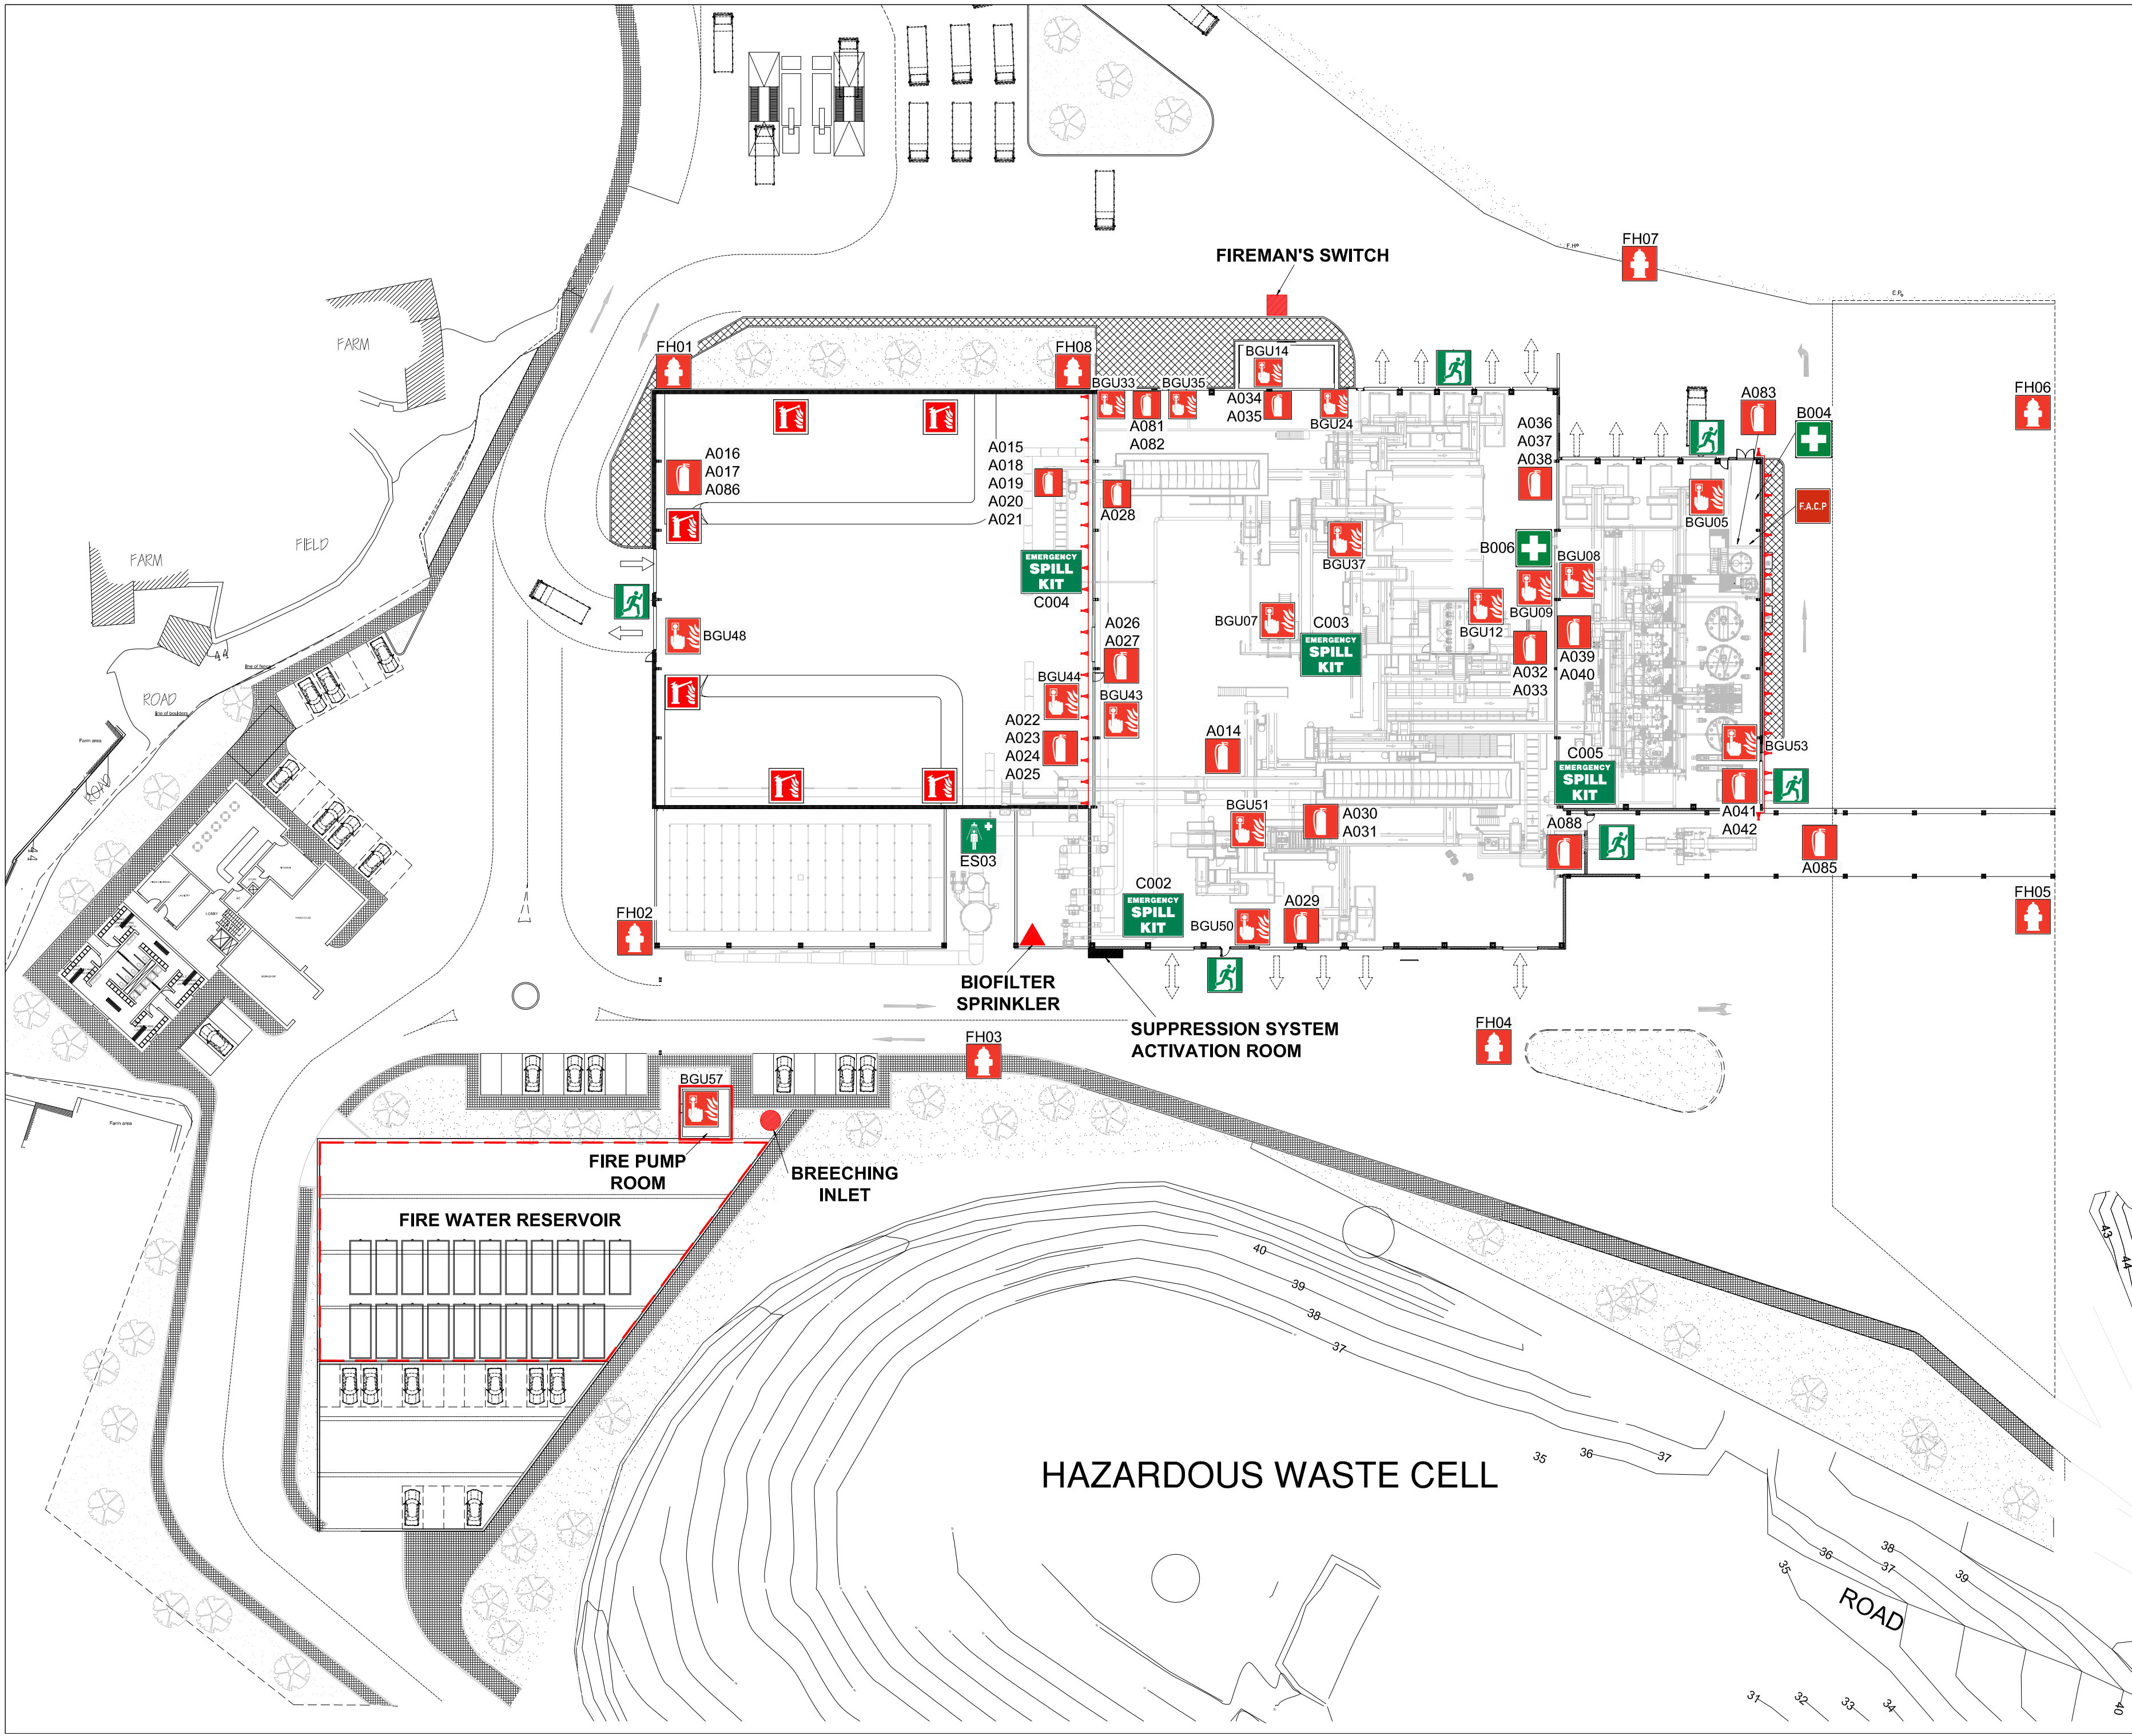


LEGEND:

- Fire Pump Room
- Fire Water Reservoir
- Suppression System Activation Room
- Breaching Inlet
- Fire Hydrants
- Fire Monitors
- Biofilter Sprinkler
- Drencher Nozzles
- Fireman's Switch
- Fire Alarm Control Panel
- Manual Call Points
- Fire Exits
- Fire Extinguishers
- First Aid Box
- Emergency Shower
- Emergency Spill Kit
- NOTE: The Assembly Point is located next to the weighbridge**

CLIENT:			
WASTESERV CREATING RESOURCES FROM WASTE			
WASTESERV MALTA LTD.			
JOB TITLE:			
Controlled document 108b MN Fire Safety Drawings Rev 00			
DRAWING TITLE			
Mechanical Treatment Plant			
scale	date	file no.	dwg no.
A2 1:500	21/07/2017	17018	01
drawn	checked	revision suffix	
SC	SS	0	

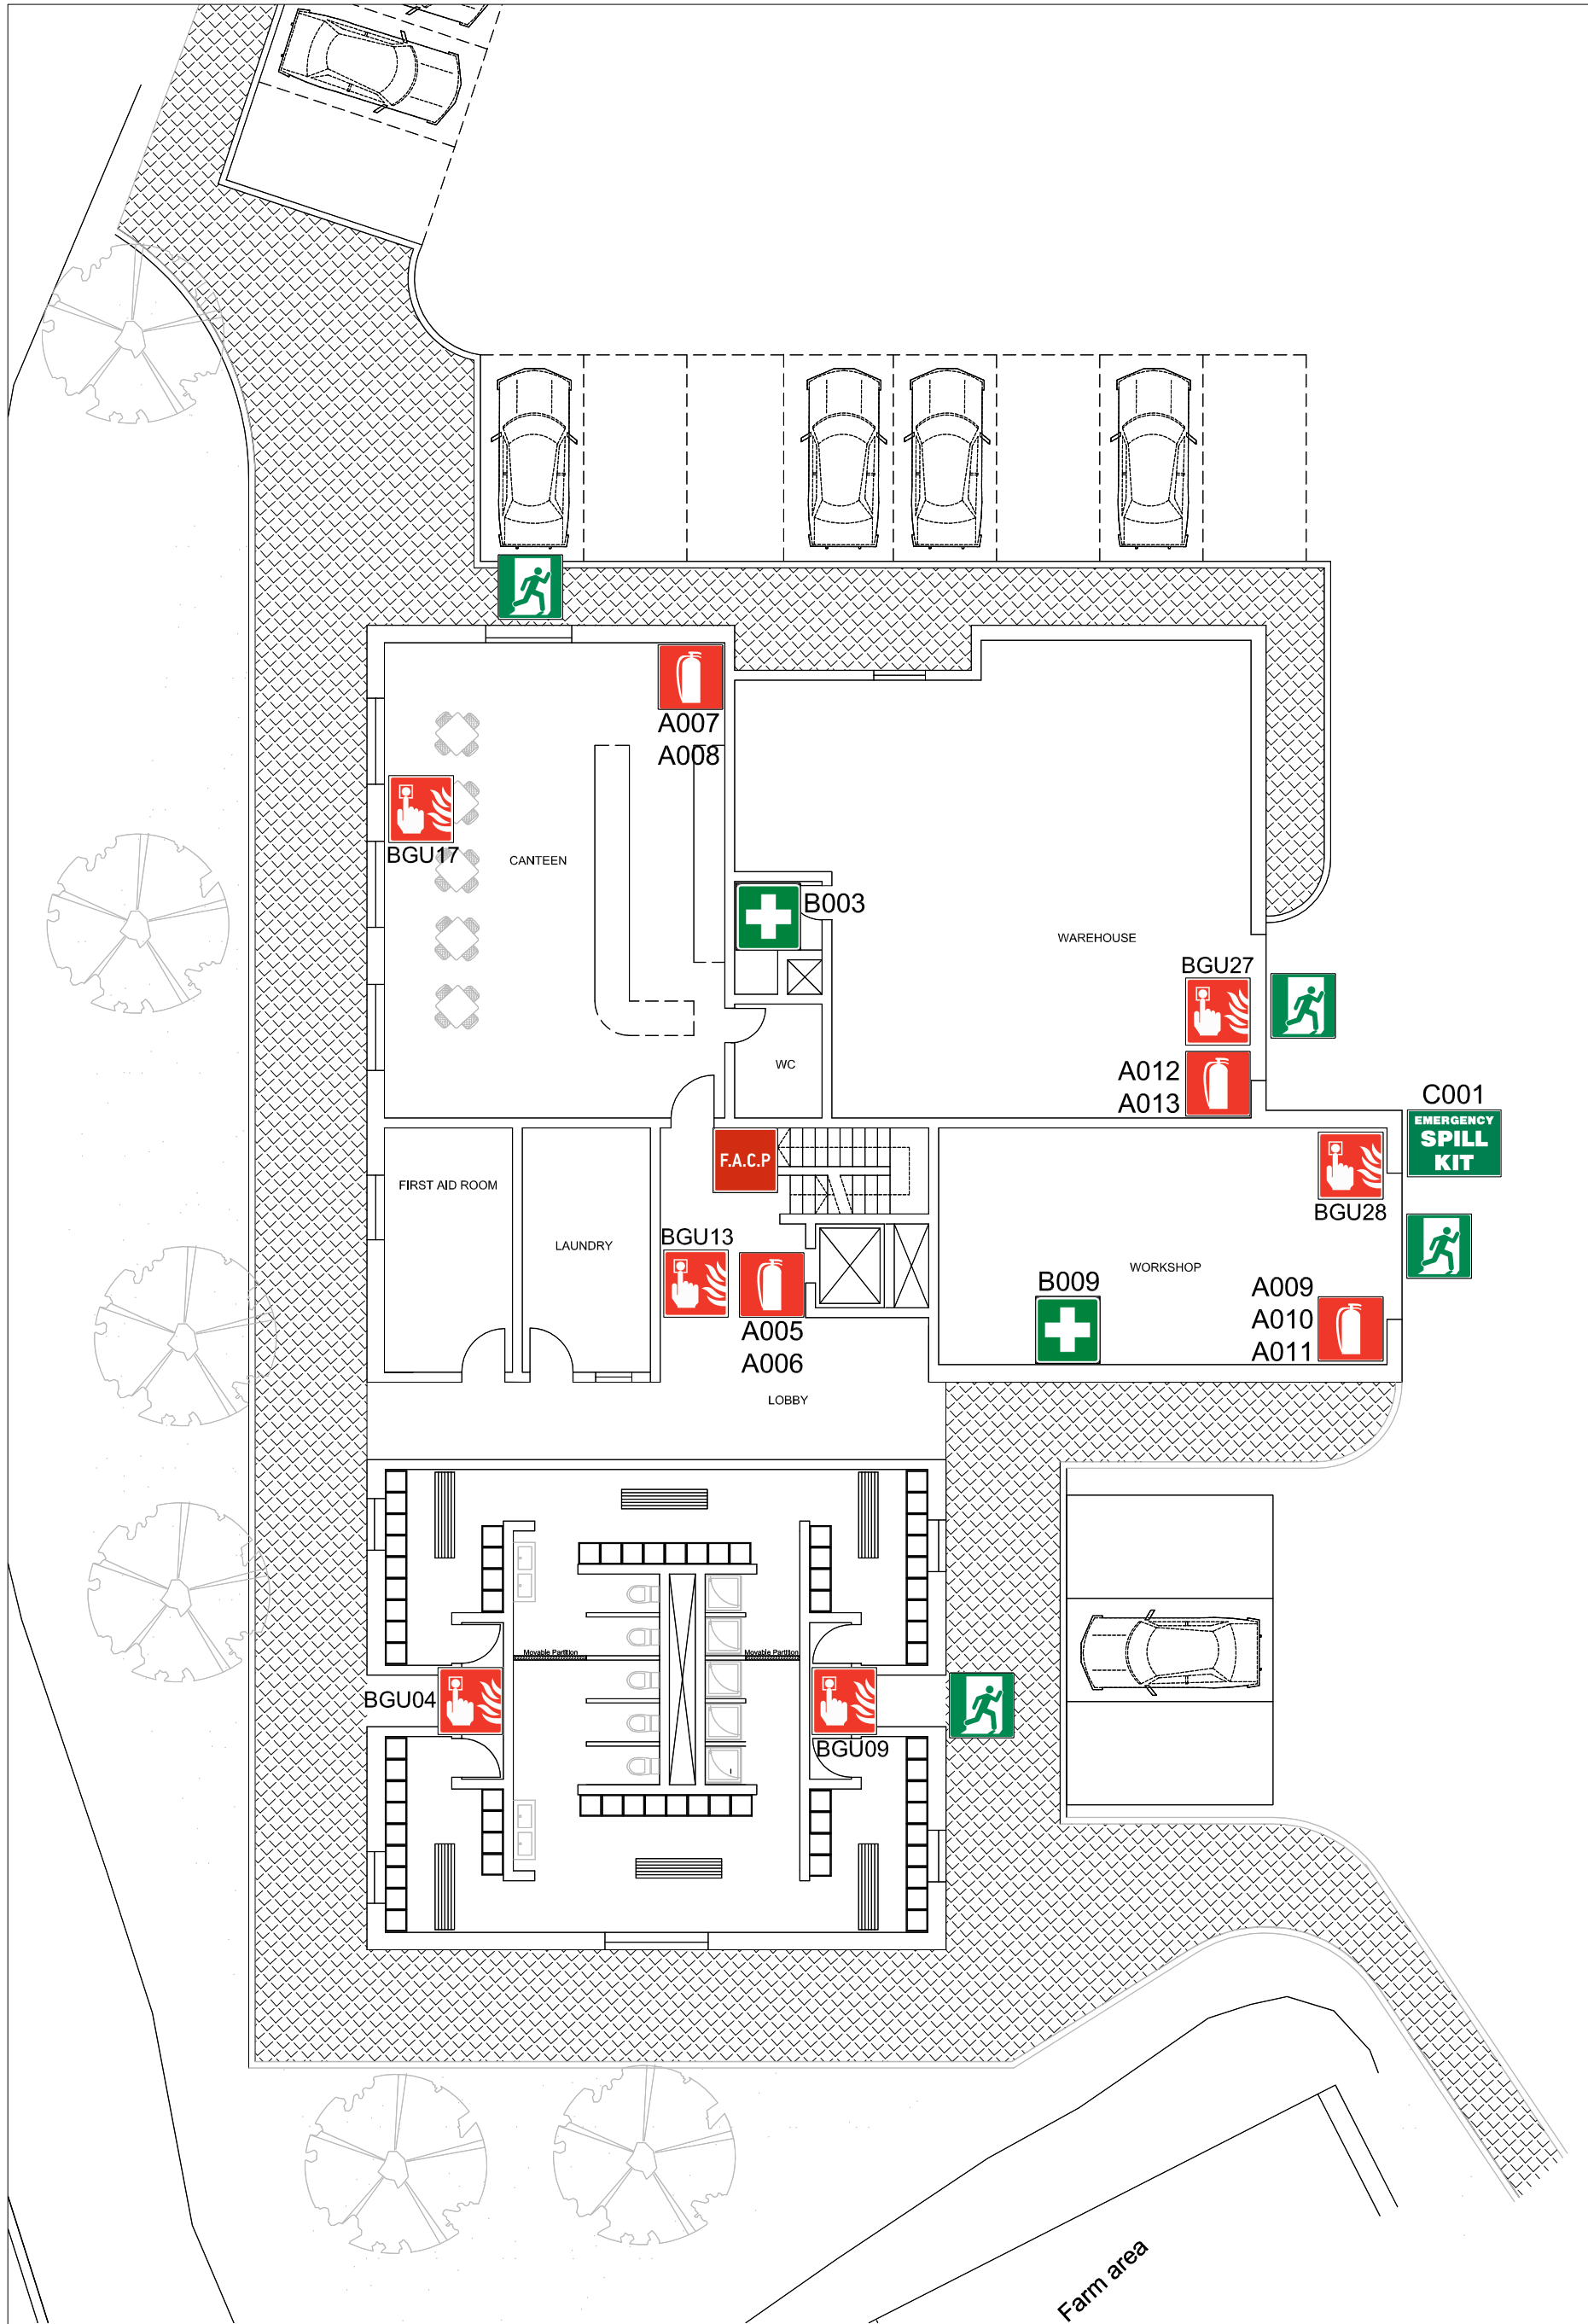



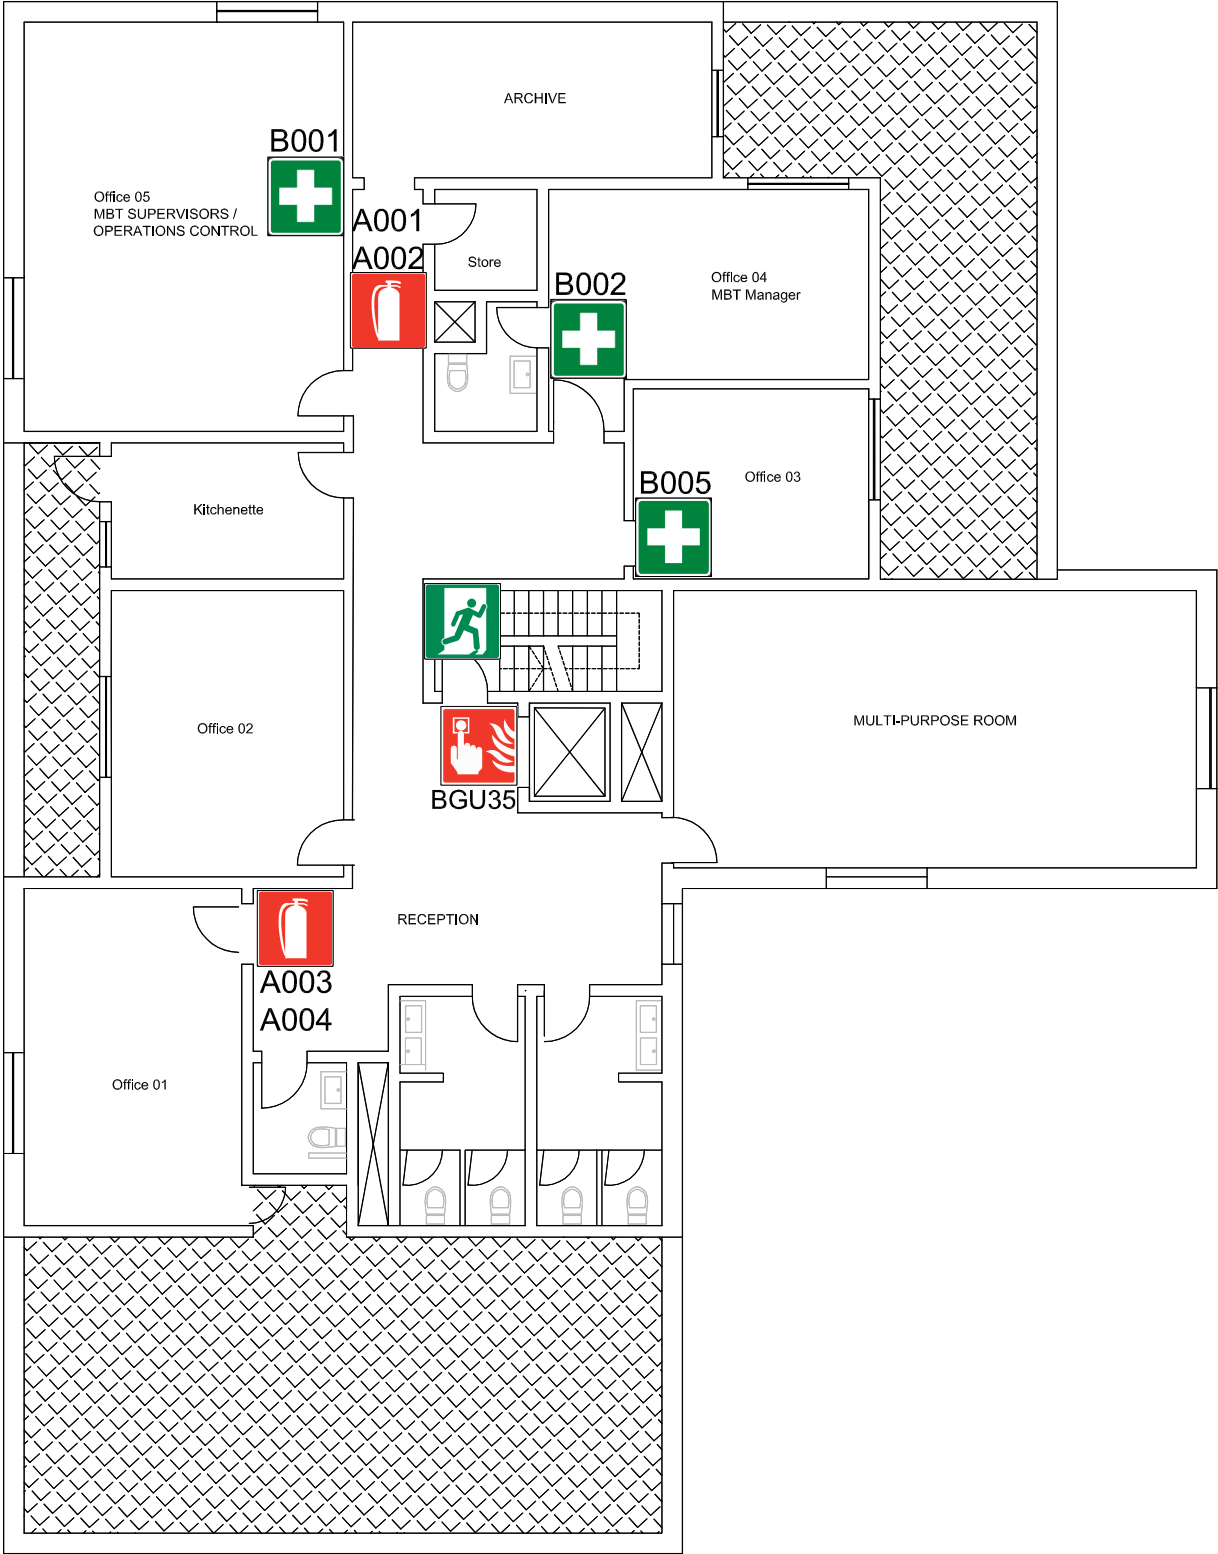




Ground Floor Plan
Administration quarters and changing rooms




First Floor Plan
Administration offices





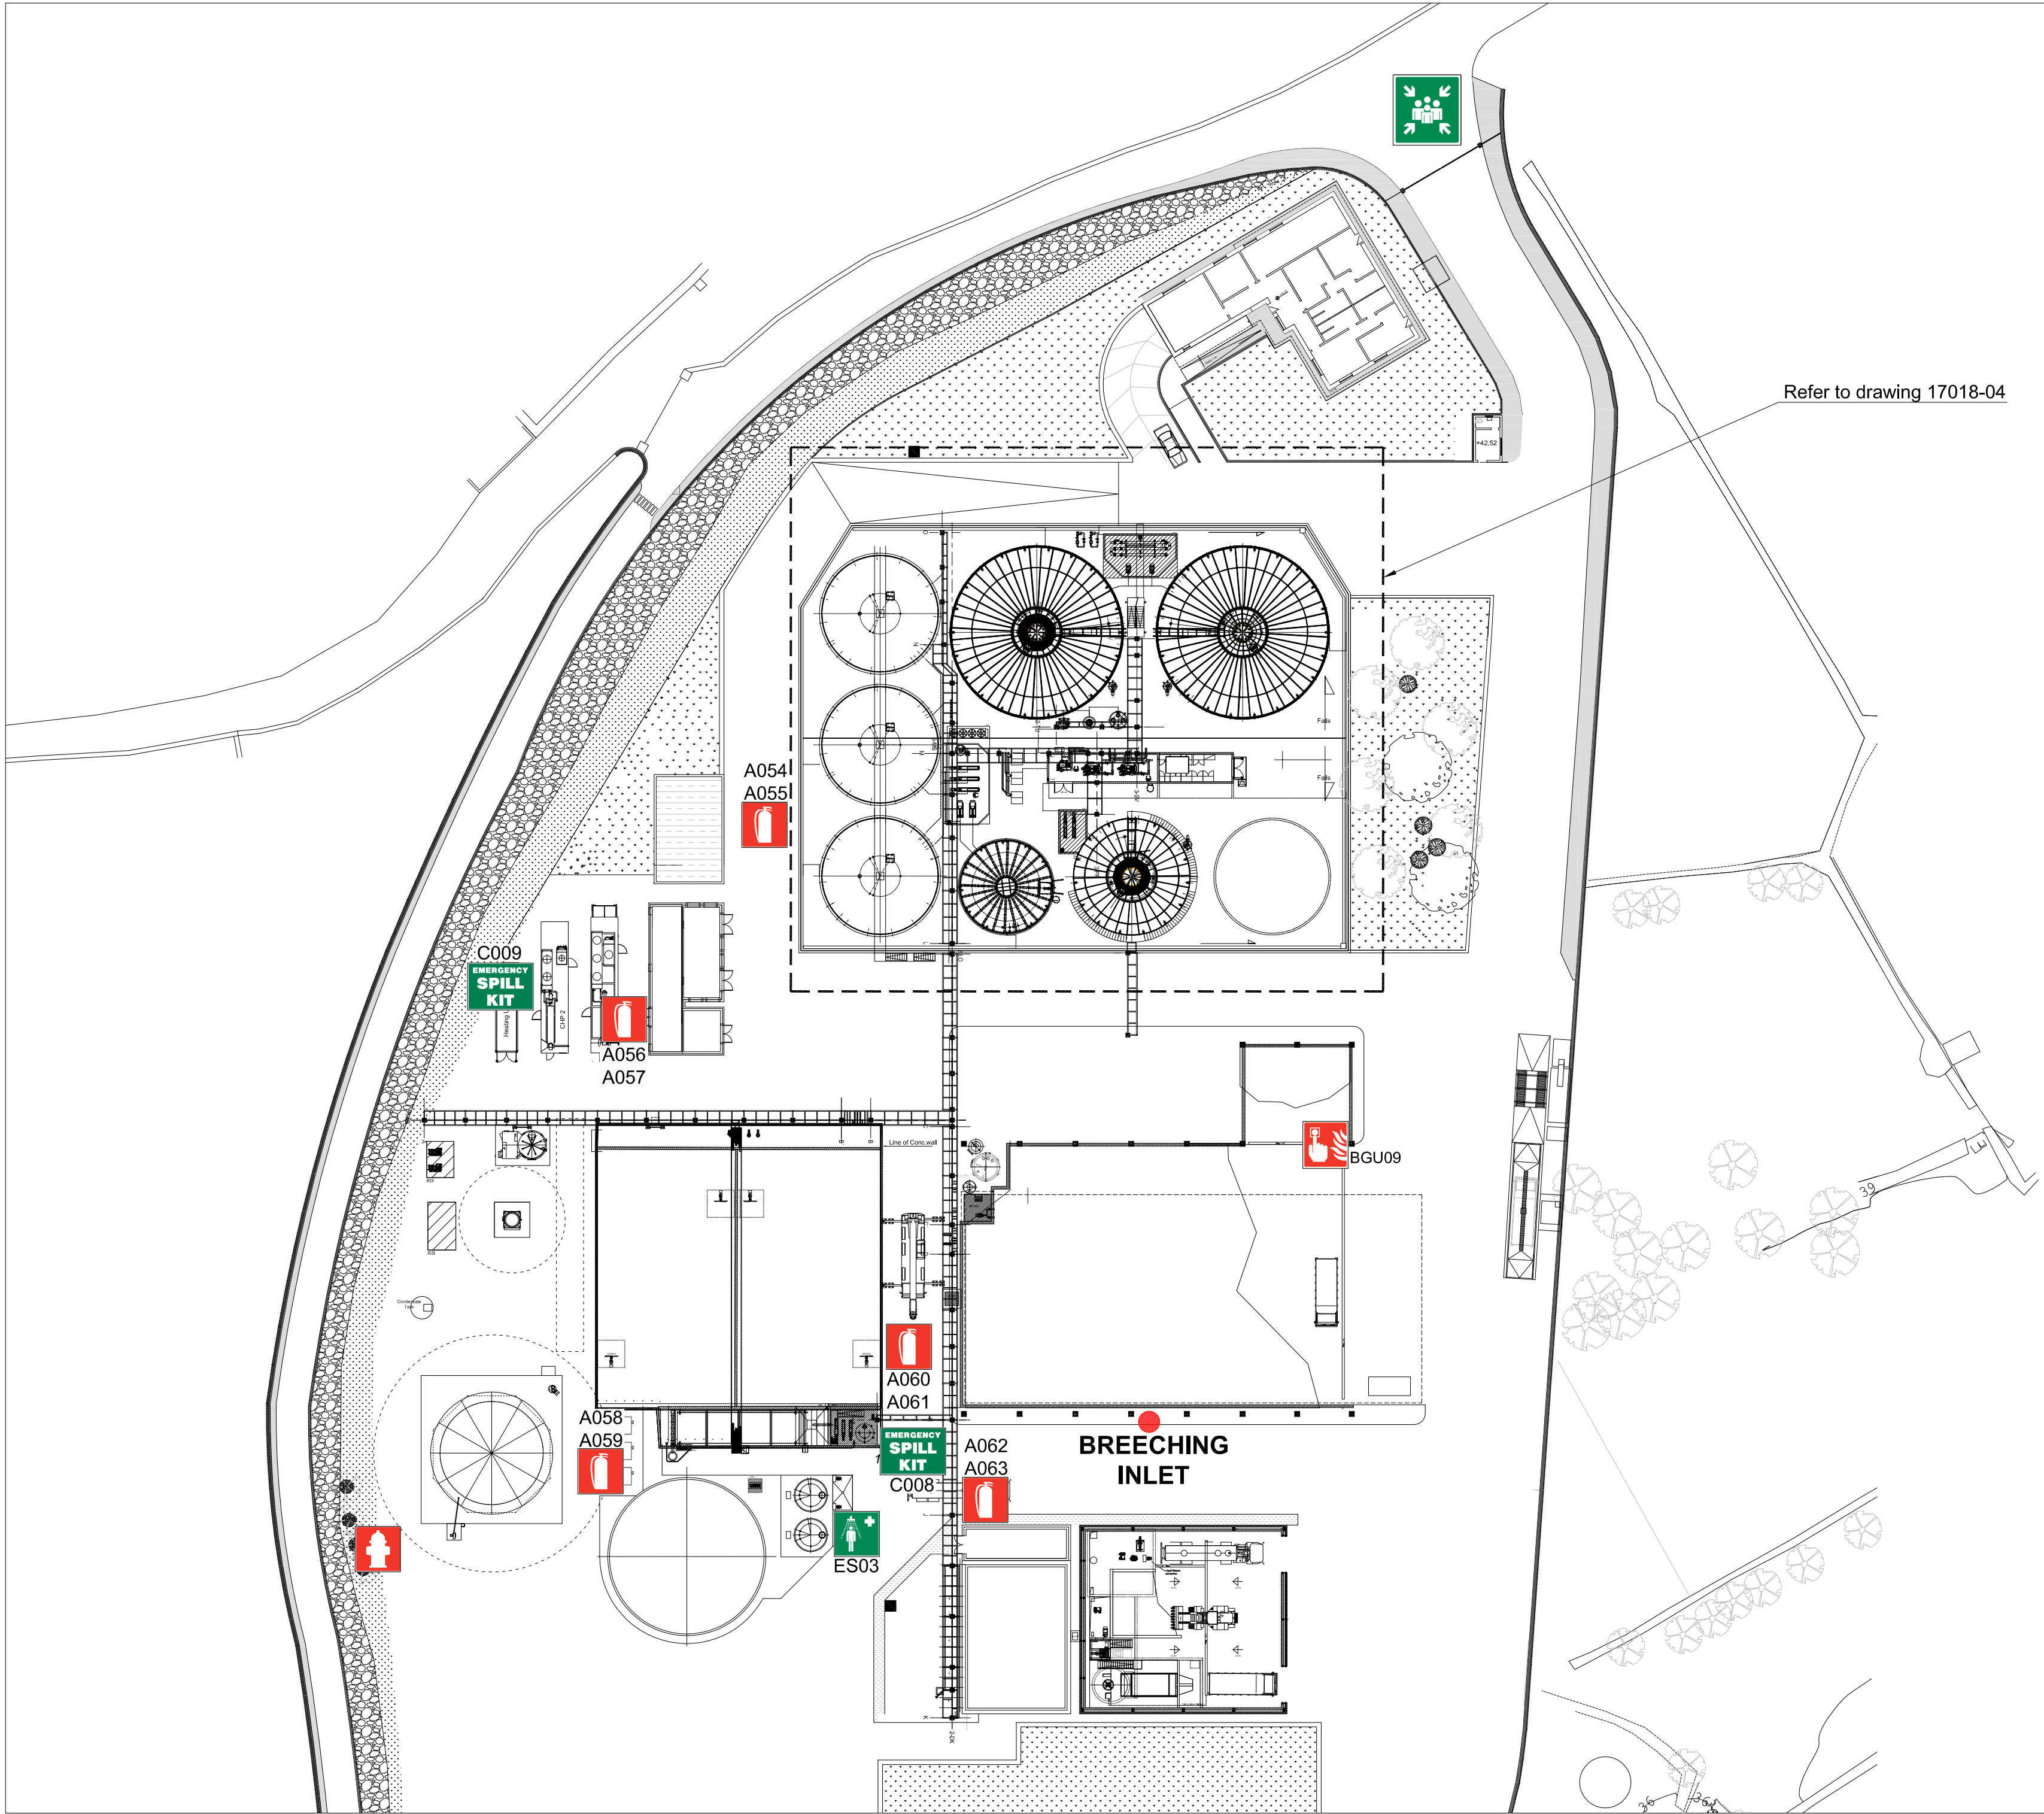

LEGEND:

-  Fire Alarm Control Panel
-  Manual Call Points
-  Fire Exits
-  Fire Extinguishers
-  First Aid Box
-  Emergency Spill Kit
-  **NOTE:** The Assembly Point is located next to the weighbridge

CLIENT:			
WASTESERV CREATING RESOURCES FROM WASTE			
WASTESERV MALTA LTD.			
JOB TITLE:			
Controlled document 108b MN Fire Safety Drawings Rev 00			
DRAWING TITLE			
Mechanical & Biological Treatment Plant Administration Building			
scale	date	file no.	dwg no.
A2 1:200	21/07/2017	17018	02
drawn	checked	revision suffix	
SC	SS	0	



LEGEND:

-  Breeching Inlet
-  Fire Hydrants
-  Fire Extinguishers
-  Emergency Shower
-  Emergency Spill Kit
-  **Note: Assembly Point is located outside the gate**

CLIENT:



WASTESERV MALTA LTD.


JOB TITLE:

Controlled document 108b
MN Fire Safety Drawings Rev 00




DRAWING TITLE


Anaerobic Digestion Plant

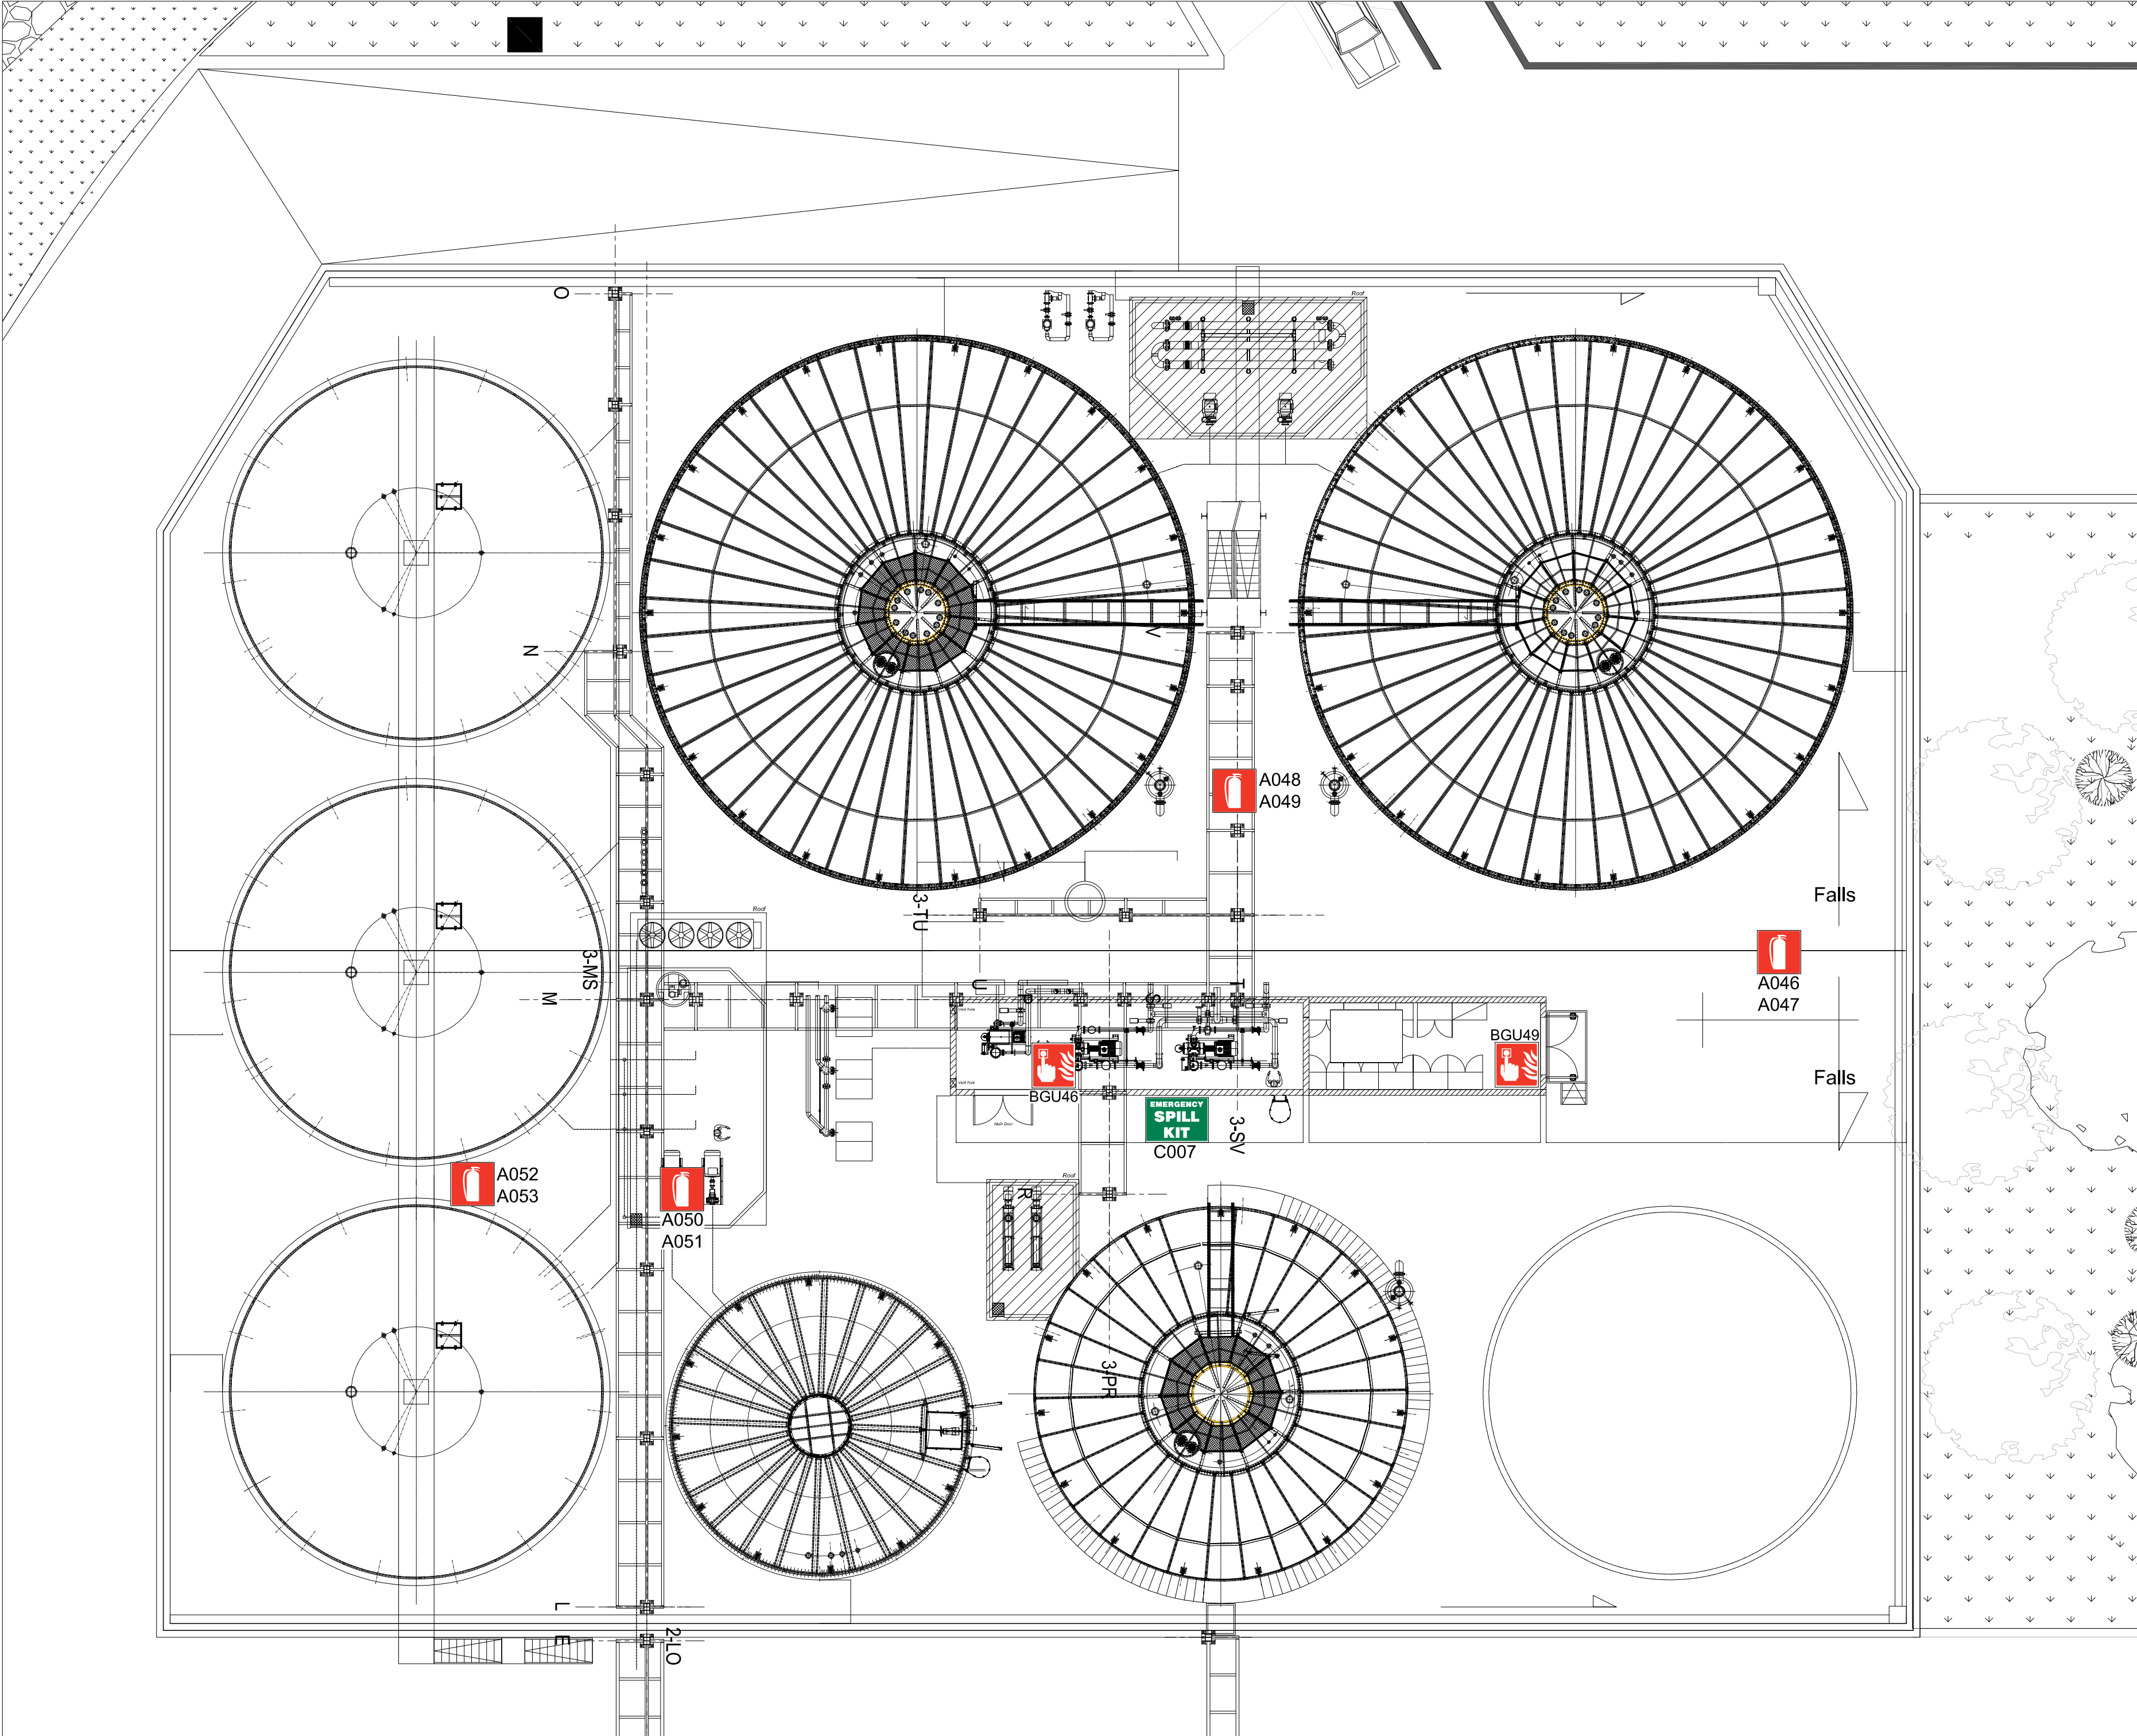scale	date	file no.	dwg no.
A2 1:500	21/07/2017	17018	03
drawn	checked	revision suffix	
SC	SS	0	



LEGEND:

-  Manual Call Points
-  Fire Extinguishers
-  Emergency Spill Kit

 **NOTE:** The Assembly Point is located outside the gate

CLIENT:



WASTESERV MALTA LTD.


JOB TITLE:

Controlled document 108b
MN Fire Safety Drawings Rev 00




DRAWING TITLE

Anaerobic Digestion Plant
Digester Zone

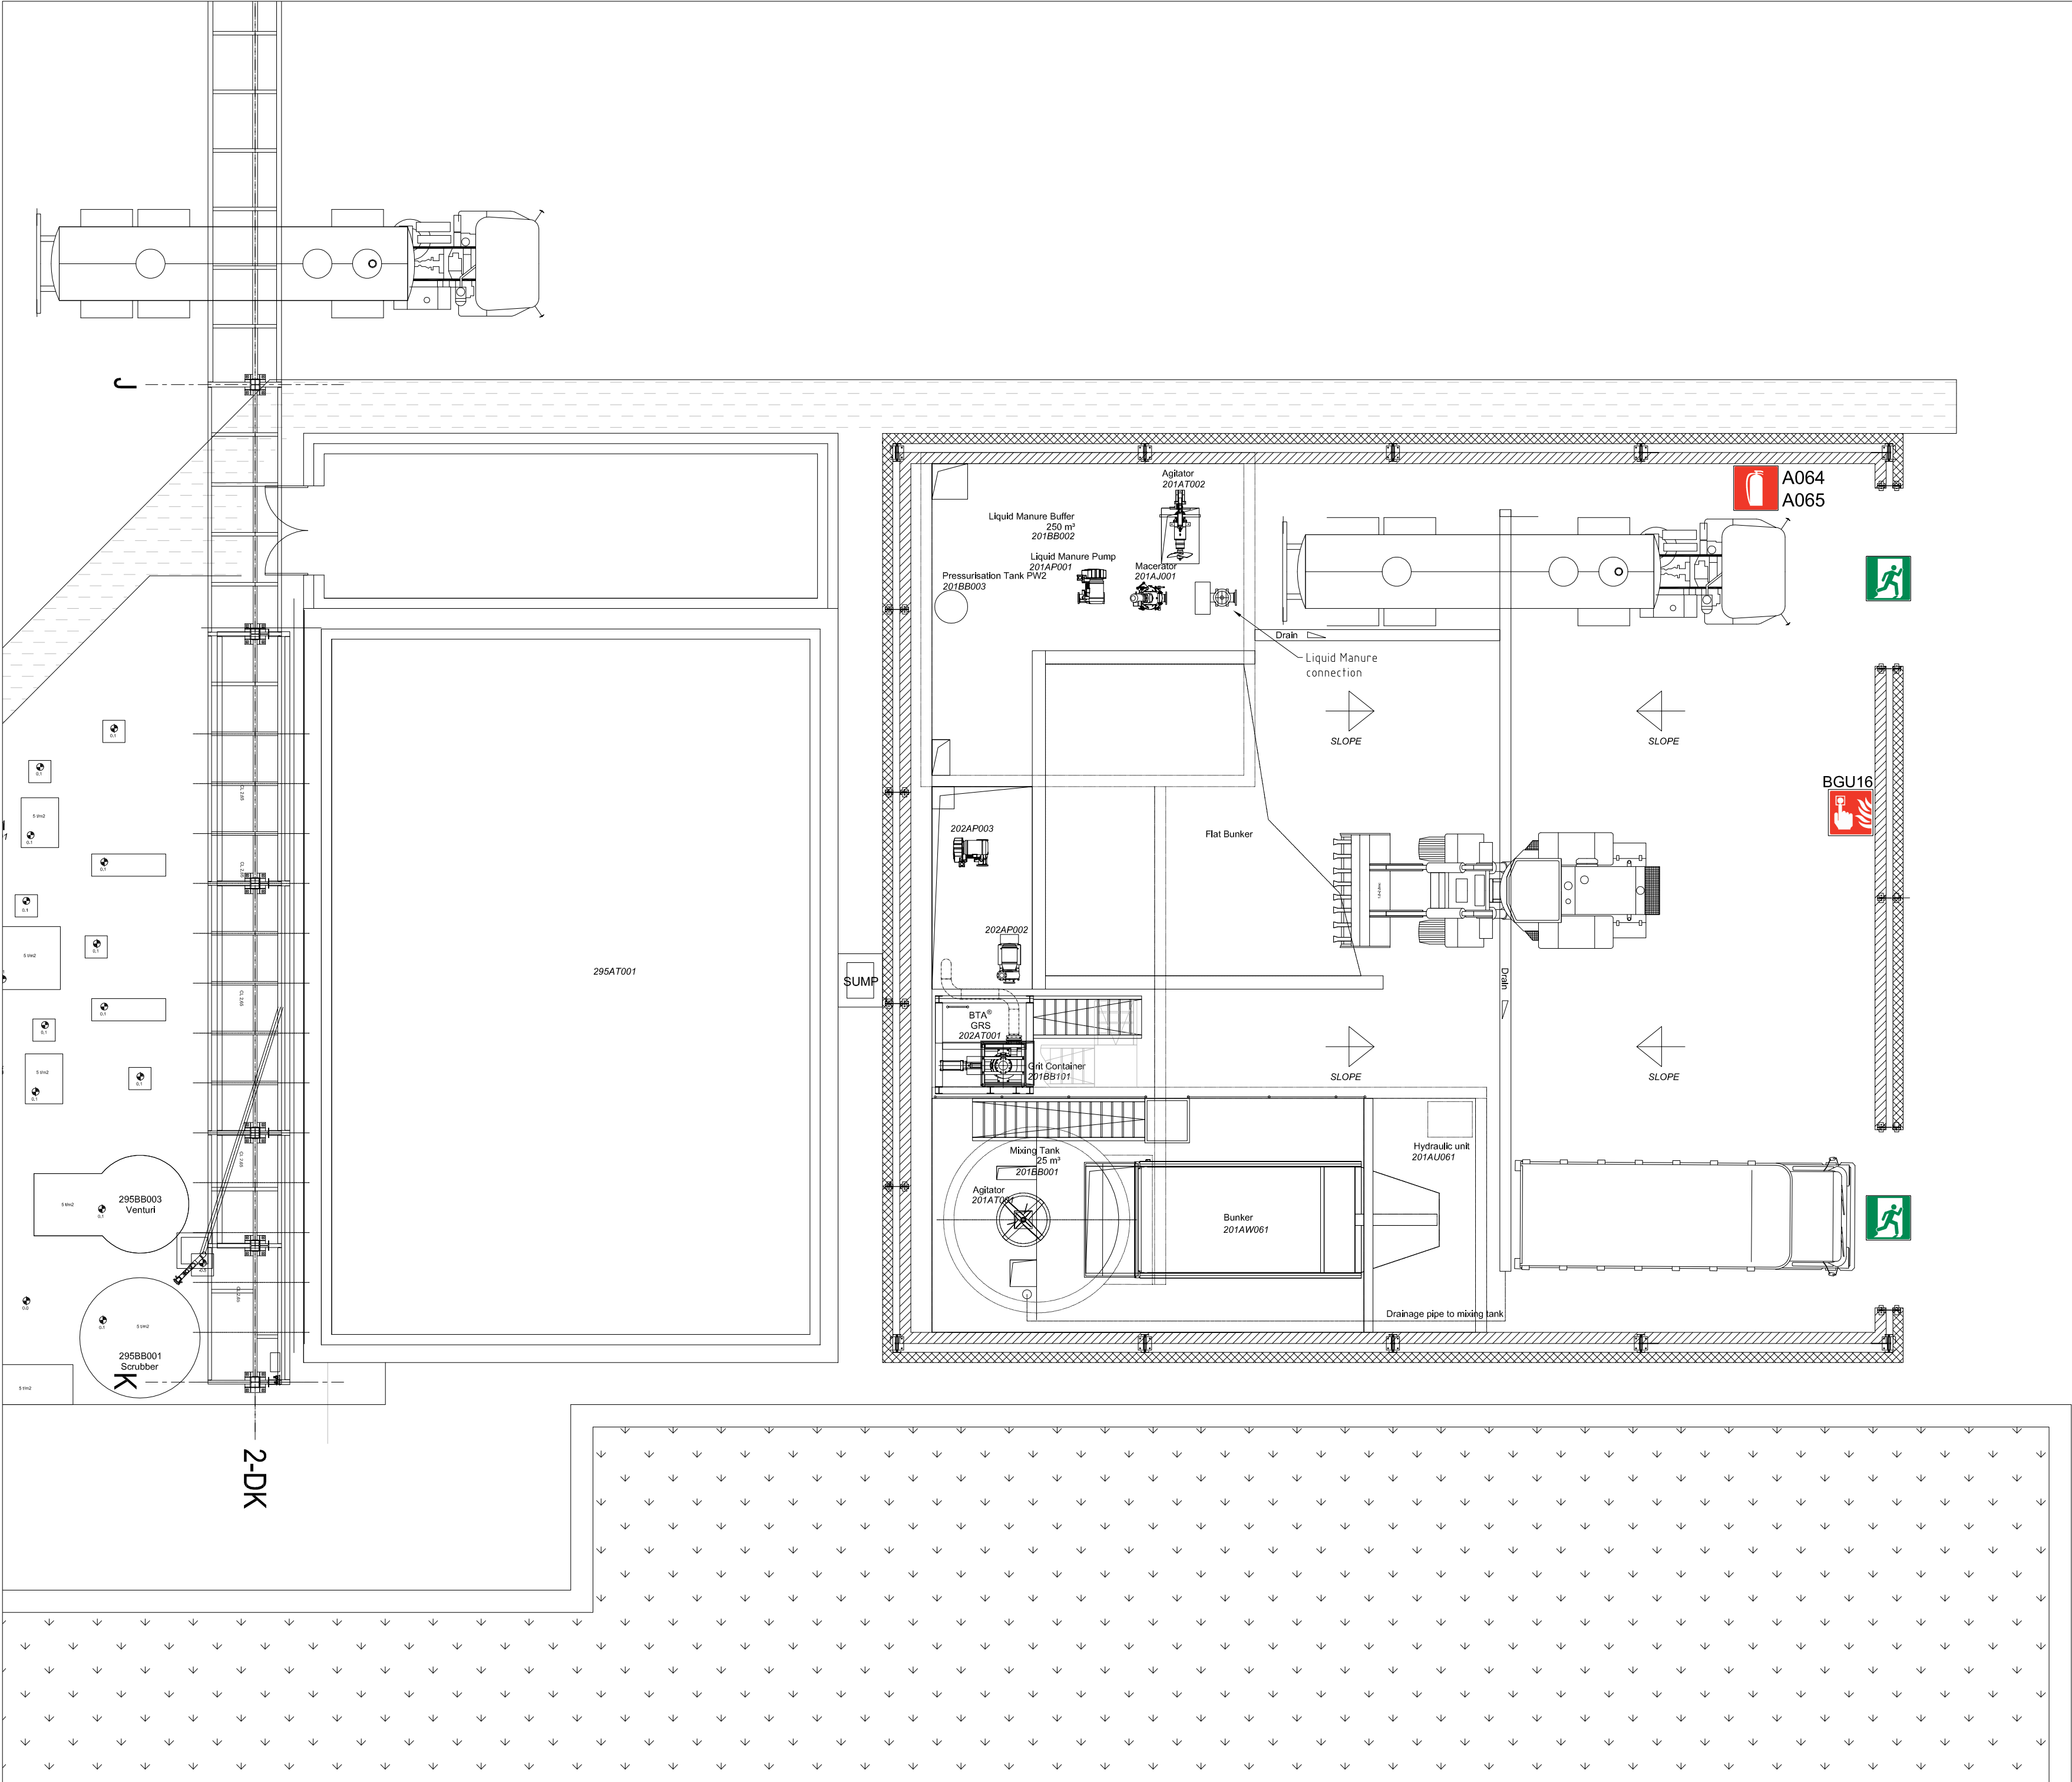scale	date	file no.	dwg no.
A2 1:150	21/07/2017	17018	04
drawn	checked	revision suffix	
SC	SS	0	




LEGEND:


-  Manual Call Points
-  Fire Extinguishers
-  Fire Exit

 **NOTE:** The Assembly Point is located outside the gate

CLIENT:			
			
WASTESERV MALTA LTD.			
JOB TITLE:			
Controlled document 108b MN Fire Safety Drawings Rev 00			
DRAWING TITLE			
Anaerobic Digestion Plant Manure Shed			
scale	date	file no.	dwg no.
A2 1:100	21/07/2017	17018	05
drawn	checked	revision suffix	
SC	SS	0	

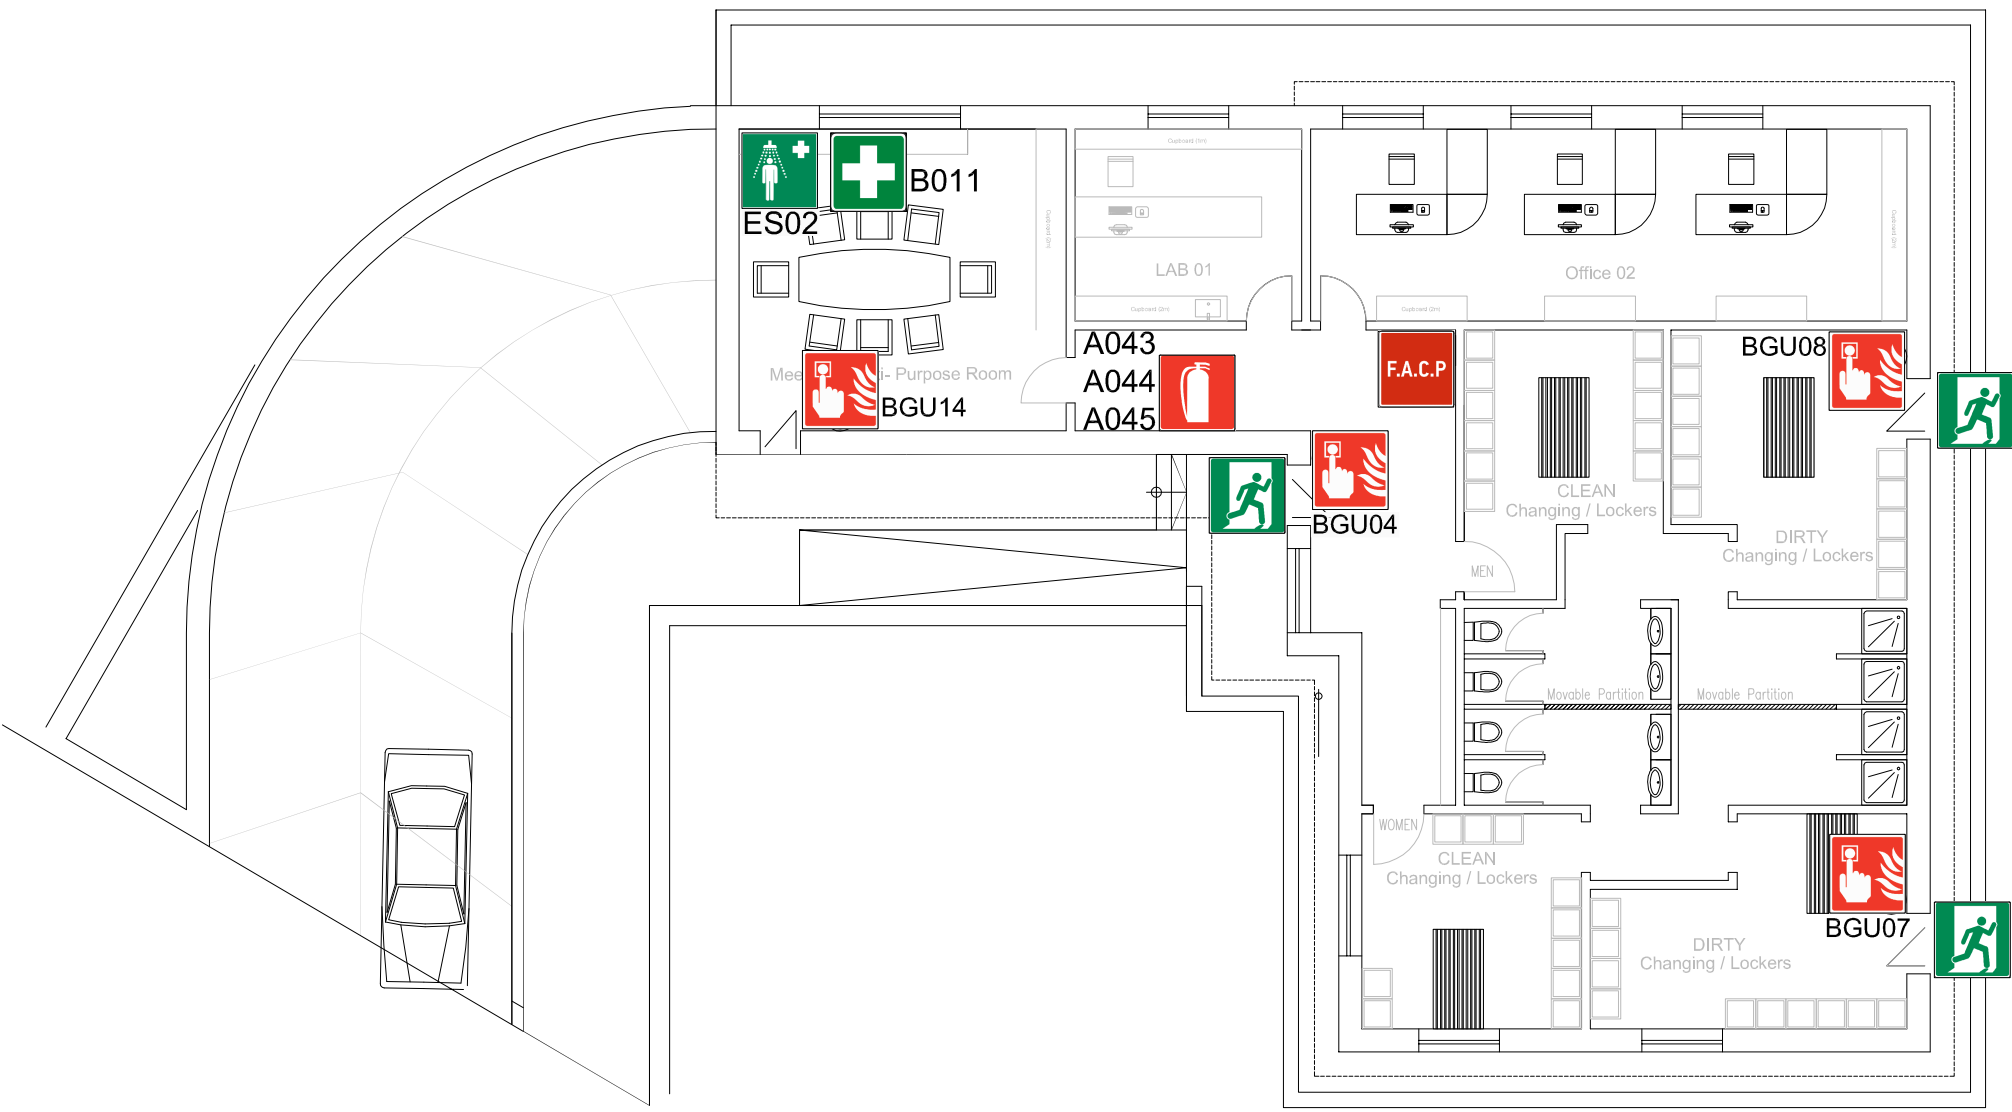



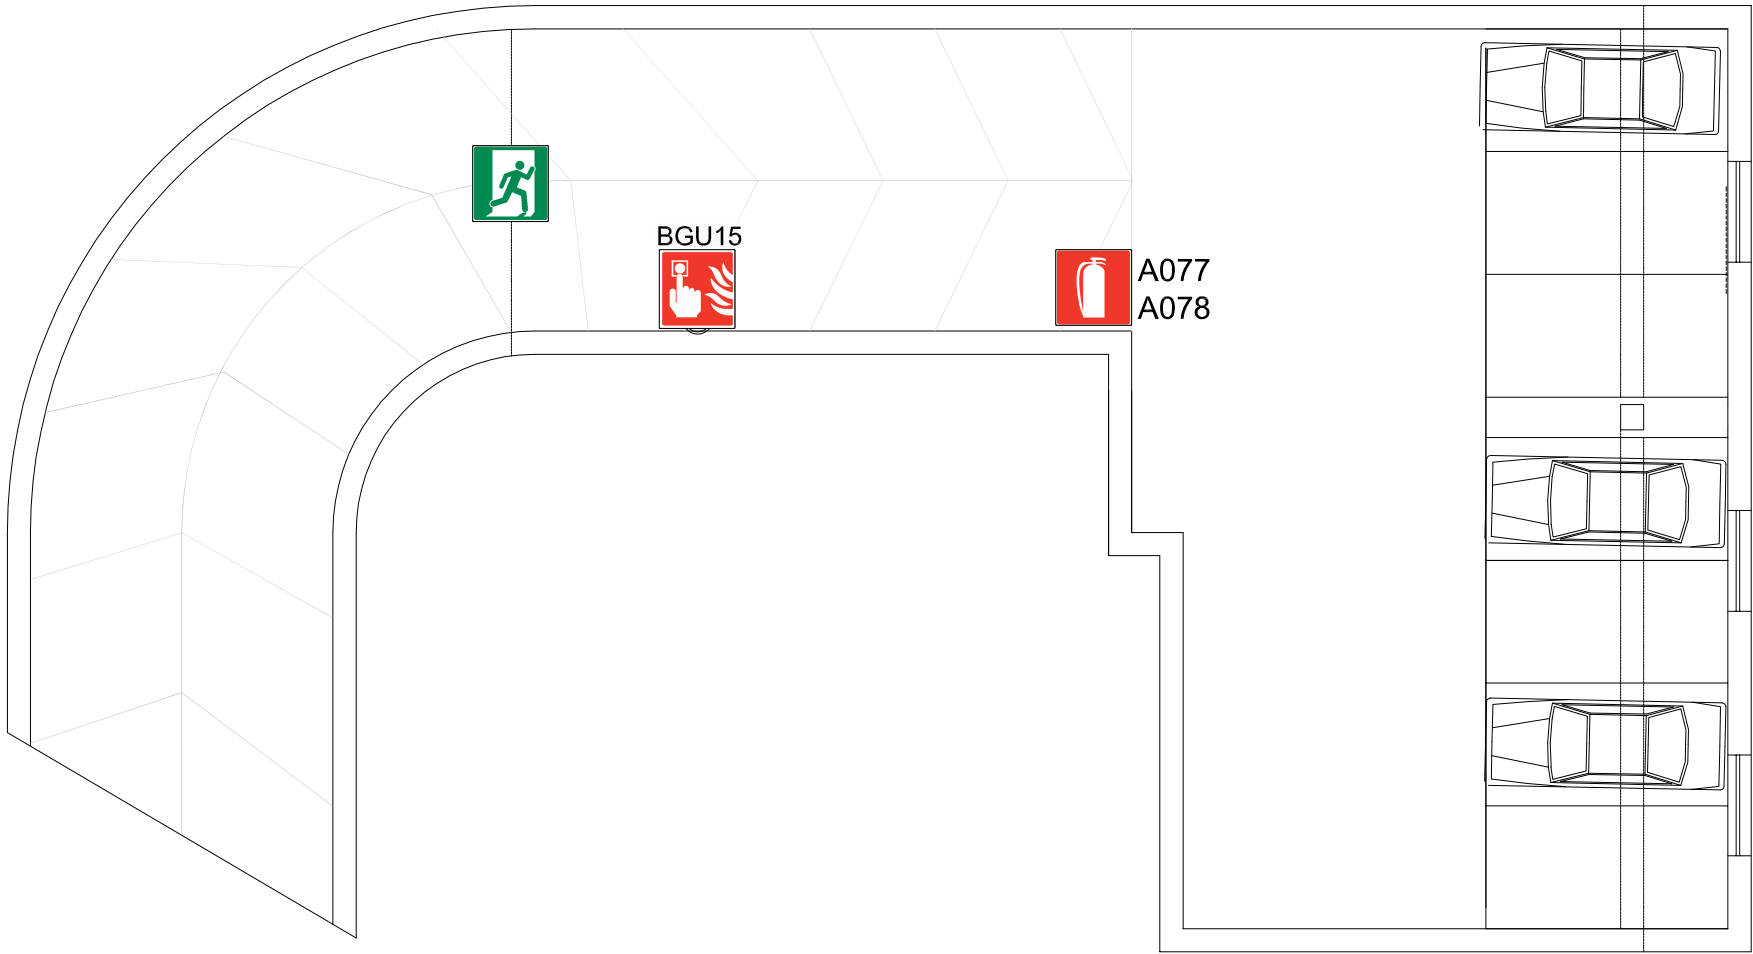




Ground Floor Plan



Basement Plan

LEGEND:

-  Fire Alarm Control Panel
-  Manual Call Points
-  Fire Exits
-  Fire Extinguishers
-  First Aid Box
-  Emergency Shower
-  **NOTE: The Assembly Point is located outside the gate**

CLIENT:

WASTESERV
CREATING RESOURCES FROM WASTE

WASTESERV MALTA LTD.


JOB TITLE:

Controlled document 108b
MN Fire Safety Drawings Rev 00


DRAWING TITLE

Anaerobic Digestion Plant
Operations Office


scale	date	file no.	dwg no.
A2 1:150	21/07/2017	17018	06
drawn	checked	revision suffix	
SC	SS	0	

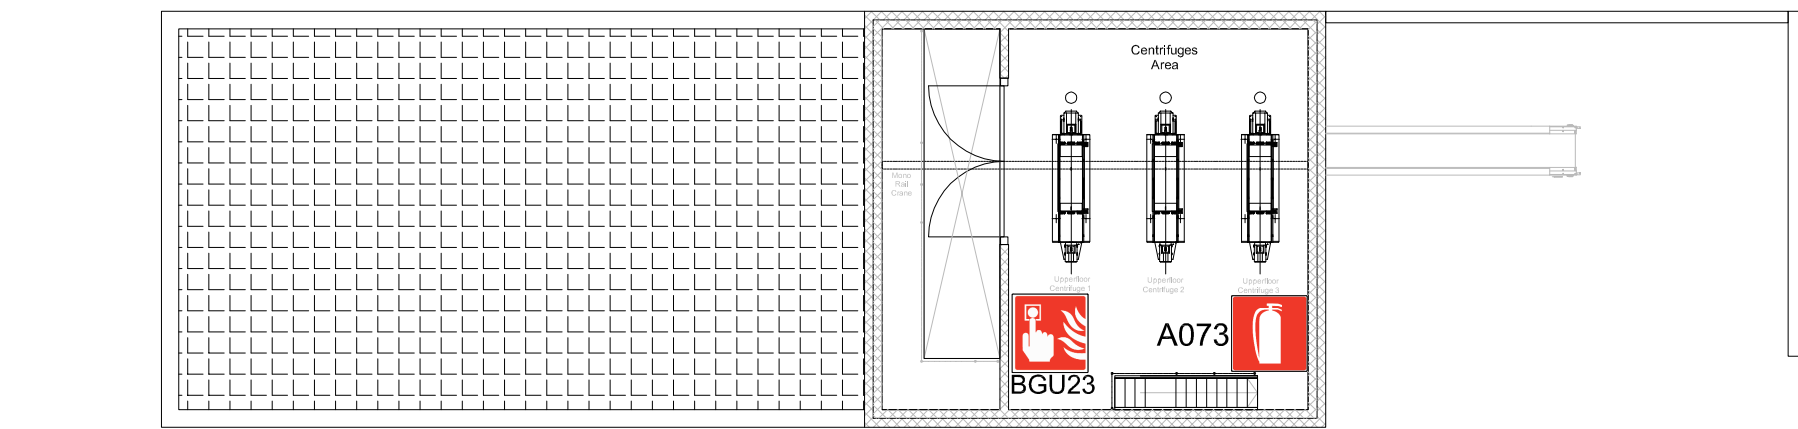

Third Floor

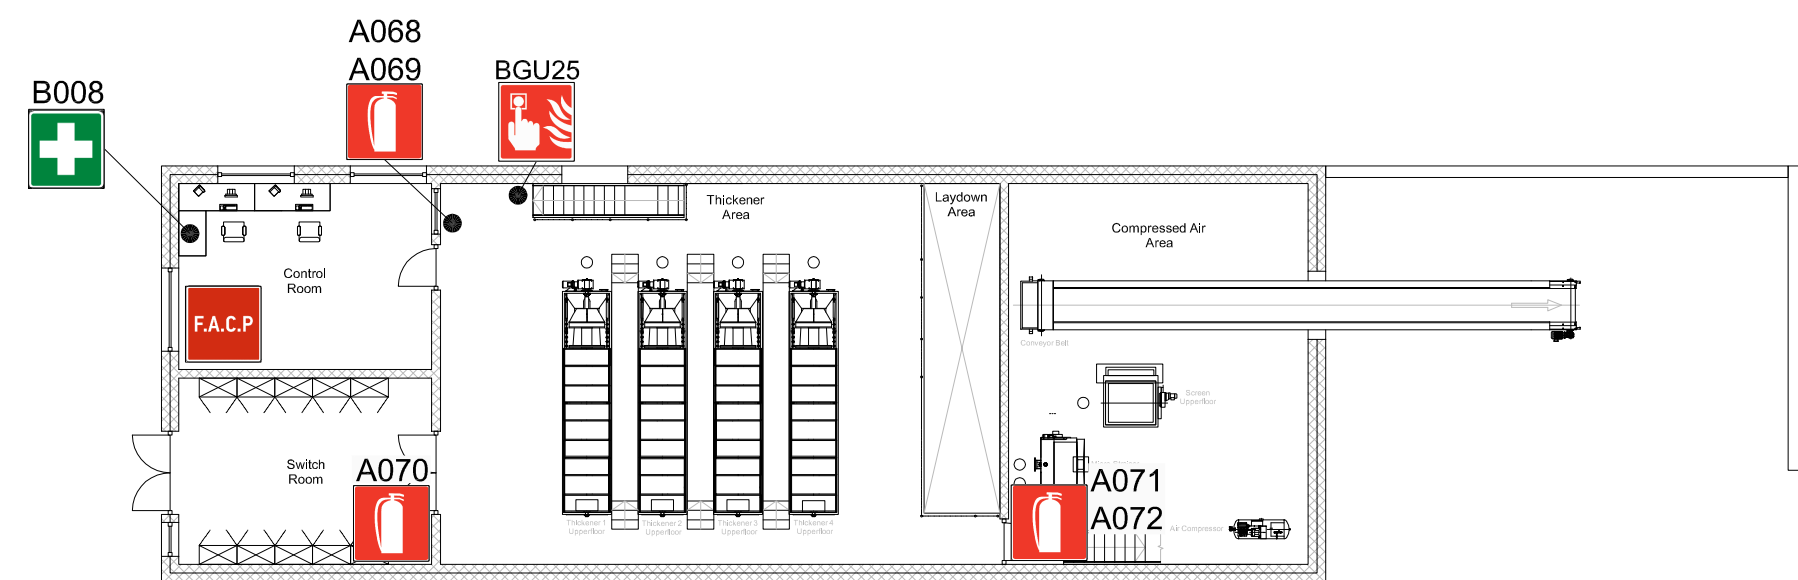

Second Floor

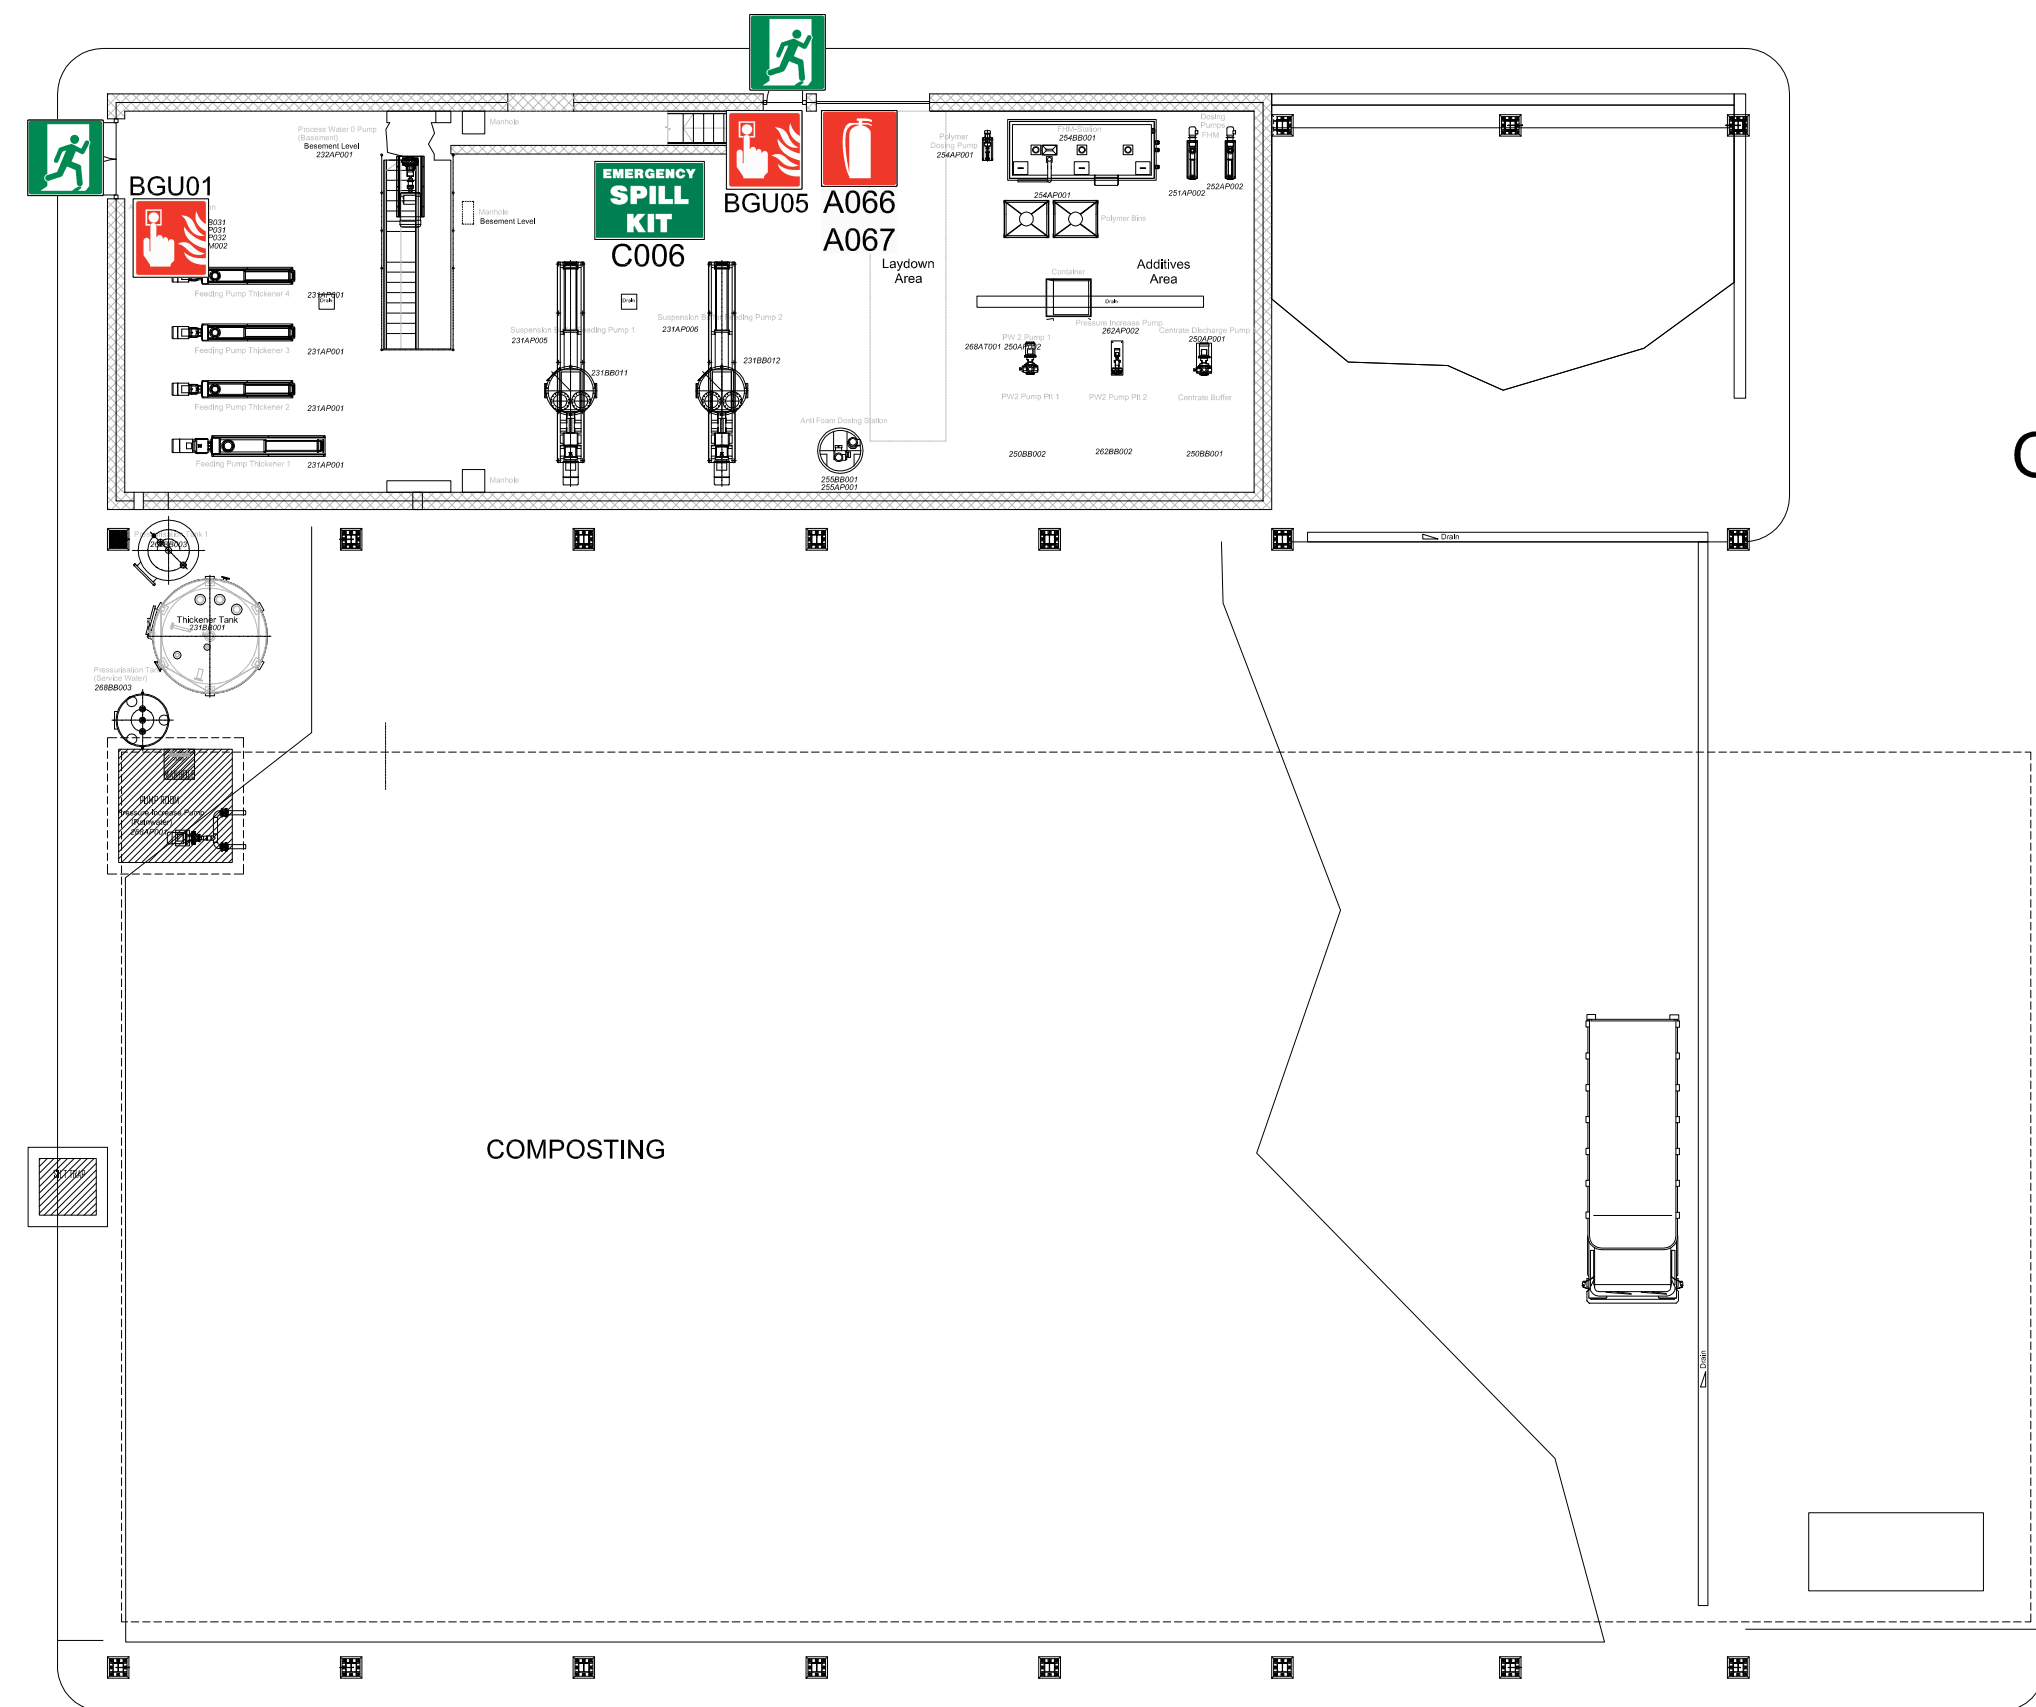

Ground Floor

LEGEND:

- Fire Alarm Control Panel
- Manual Call Points
- Fire Exits
- Fire Extinguishers
- First Aid Box
- Emergency Spill Kit
- NOTE: The Assembly Point is located outside the gate**

CLIENT:



WASTESERV MALTA LTD.

JOB TITLE:

Controlled document 108b
MN Fire Safety Drawings Rev 00

DRAWING TITLE

Anaerobic Digestion Plant
Dewatering

scale	date	file no.	dwg no.
A2 1:200	21/07/2017	17018	07
drawn	checked	revision suffix	
SC	SS	0	